



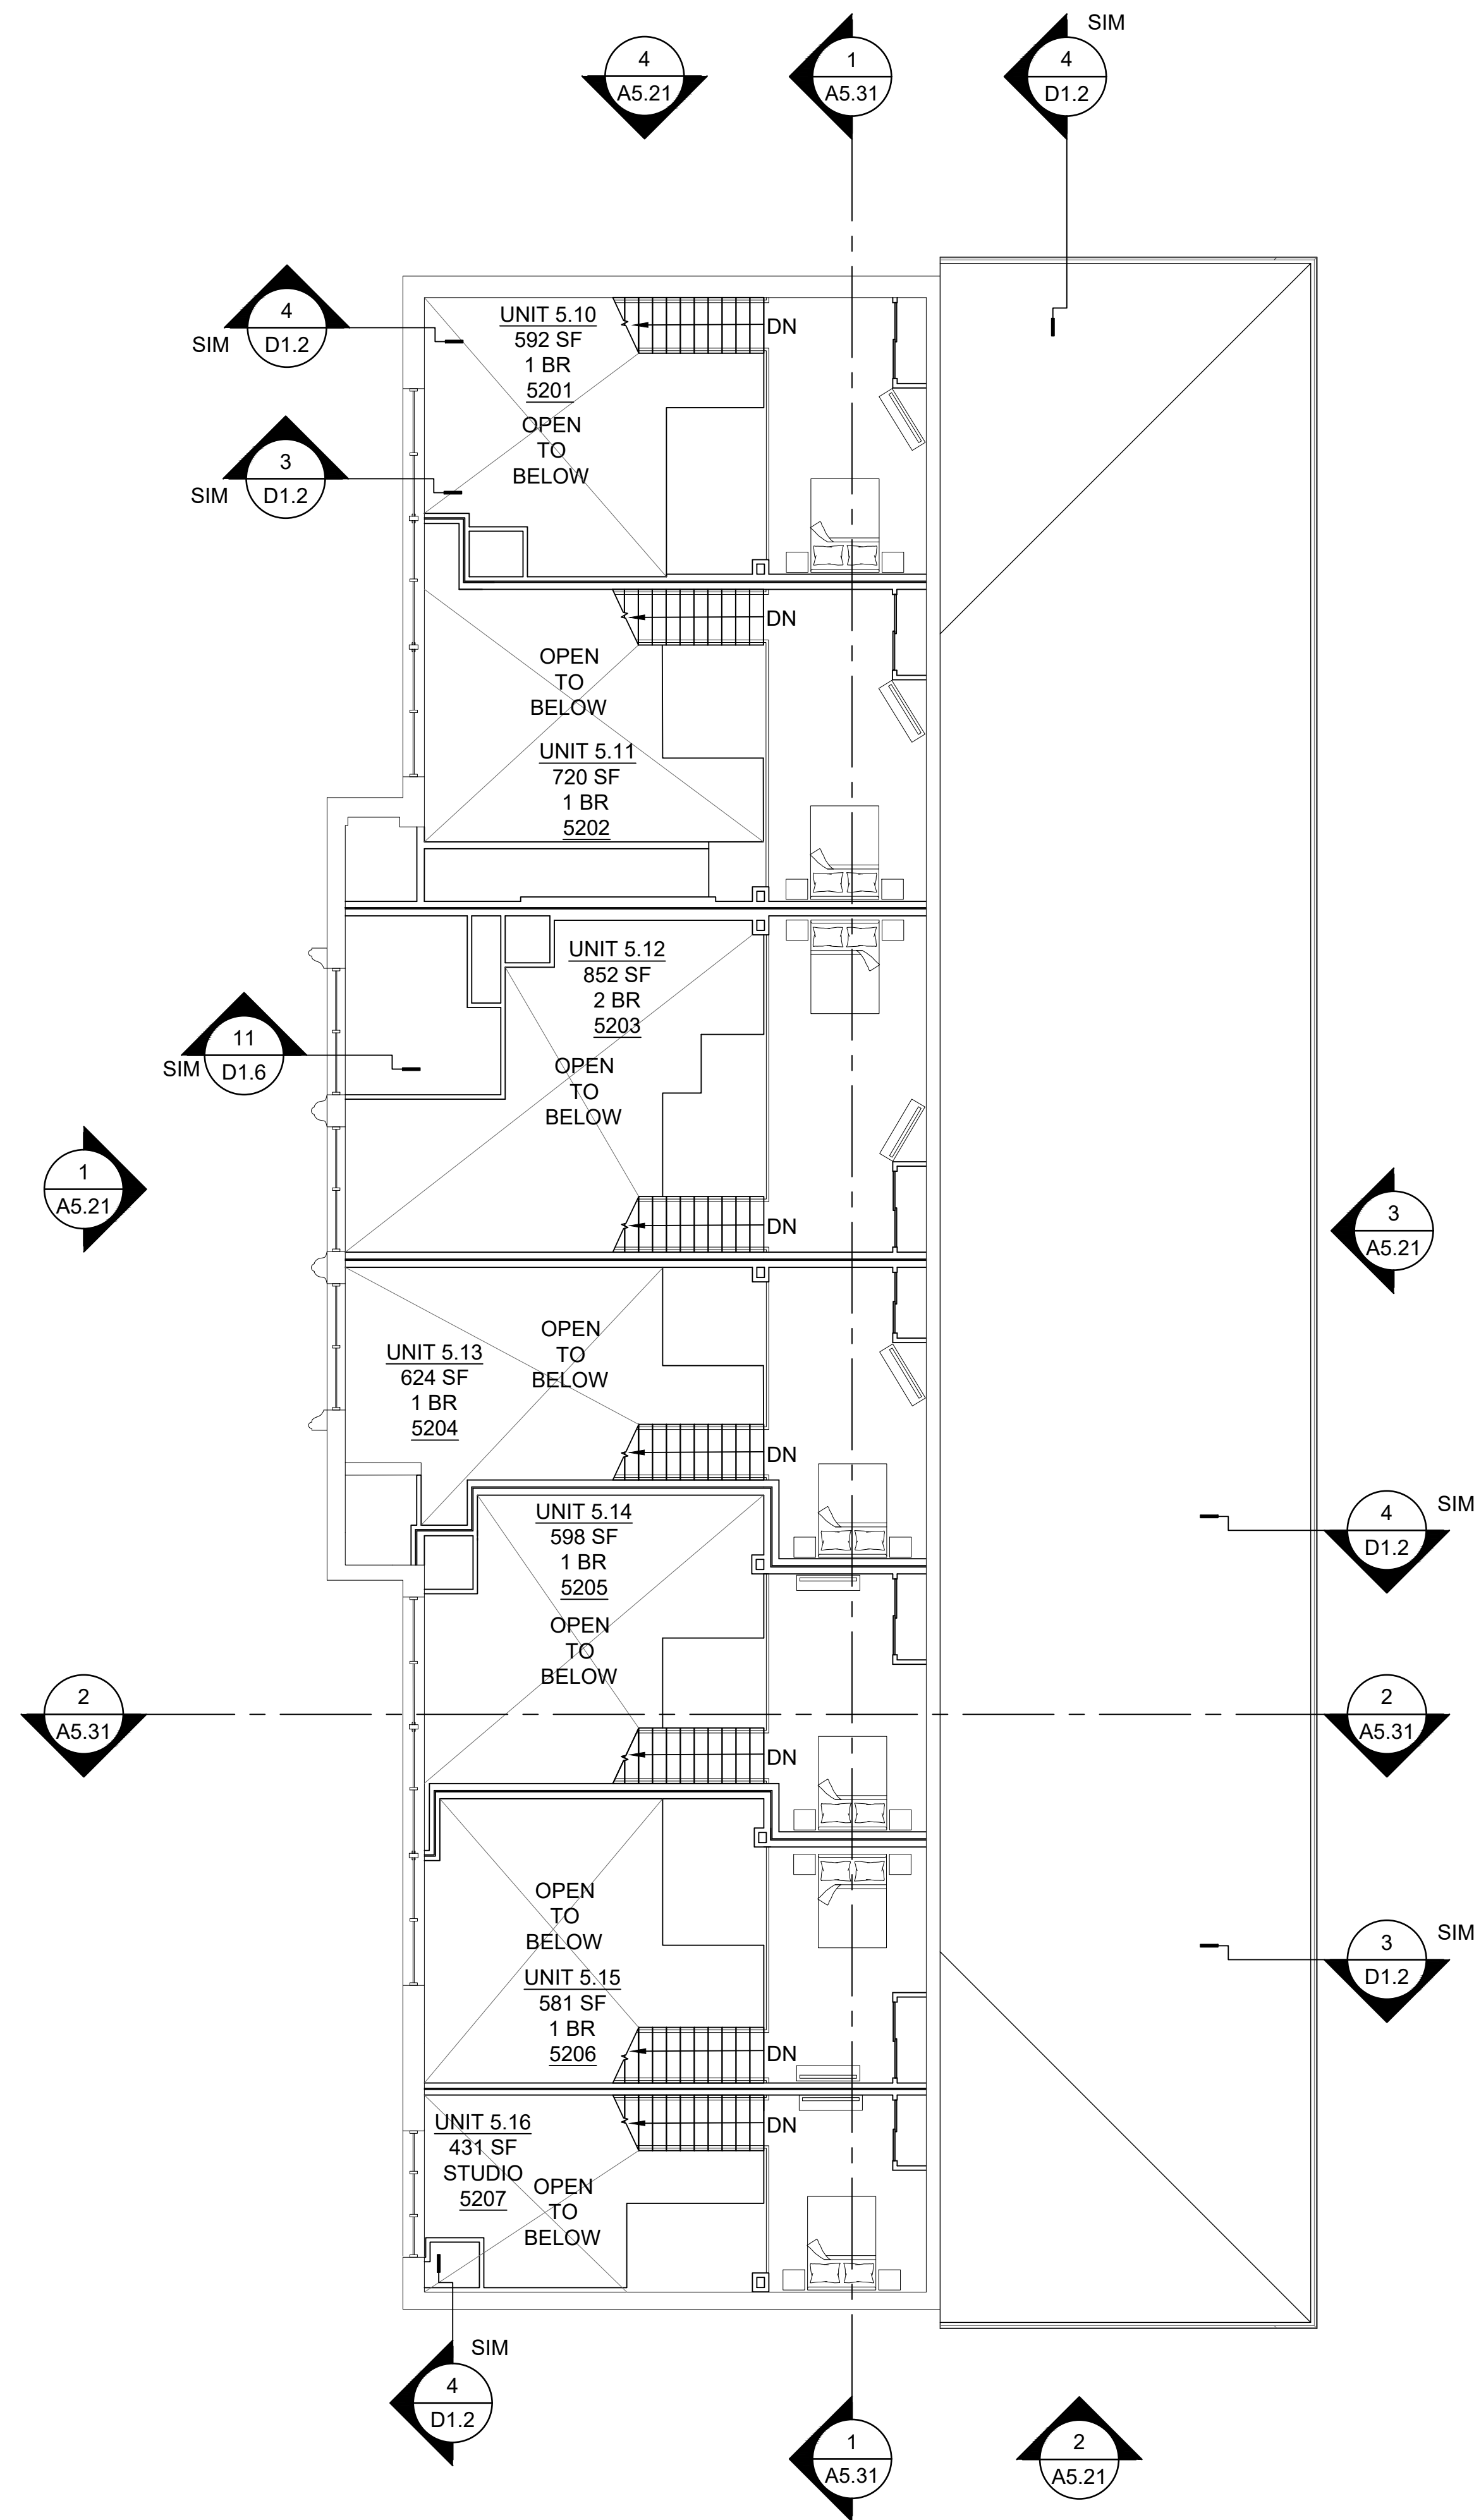



3 LOFT LEVEL FLOOR PLAN
SCALE: 1/8"=1'-0"




UNIT MIX - BUILDING 5 (08/18/25)																				TOTAL
UNIT	HC5.1	5.2	5.3	5.4	HC5.5	5.6	5.7	5.8	5.9	5.10	5.11	5.12	5.13	5.14	5.15	5.16	5.17	5.18	5.19	
TYPE	STUDIO	STUDIO	2BR	STUDIO	1BR	STUDIO	STUDIO	STUDIO	STUDIO	1BR	1BR	2BR	1BR	1BR	1BR	STUDIO	STUDIO	STUDIO	STUDIO	STUDIO
NET RENTABLE AREA	430	423	800	385	640	468	418	429	415	592	720	852	624	598	581	431	435	408	386	12345
GROSS LIVING AREA	532	492	927	476	755	550	491	499	525	712	835	957	724	694	666	527	534	471	442	13695
FLOOR 1	1	1	1	1	1	1	1	1	1	0	0	0	0	0	0	0	0	0	0	9
FLOOR 2	0	0	0	0	0	0	0	0	0	1	1	1	1	1	1	1	1	1	1	13
TOTAL	1	1	1	1	1	1	1	1	1	1	1	1	1	1	1	1	1	1	1	22

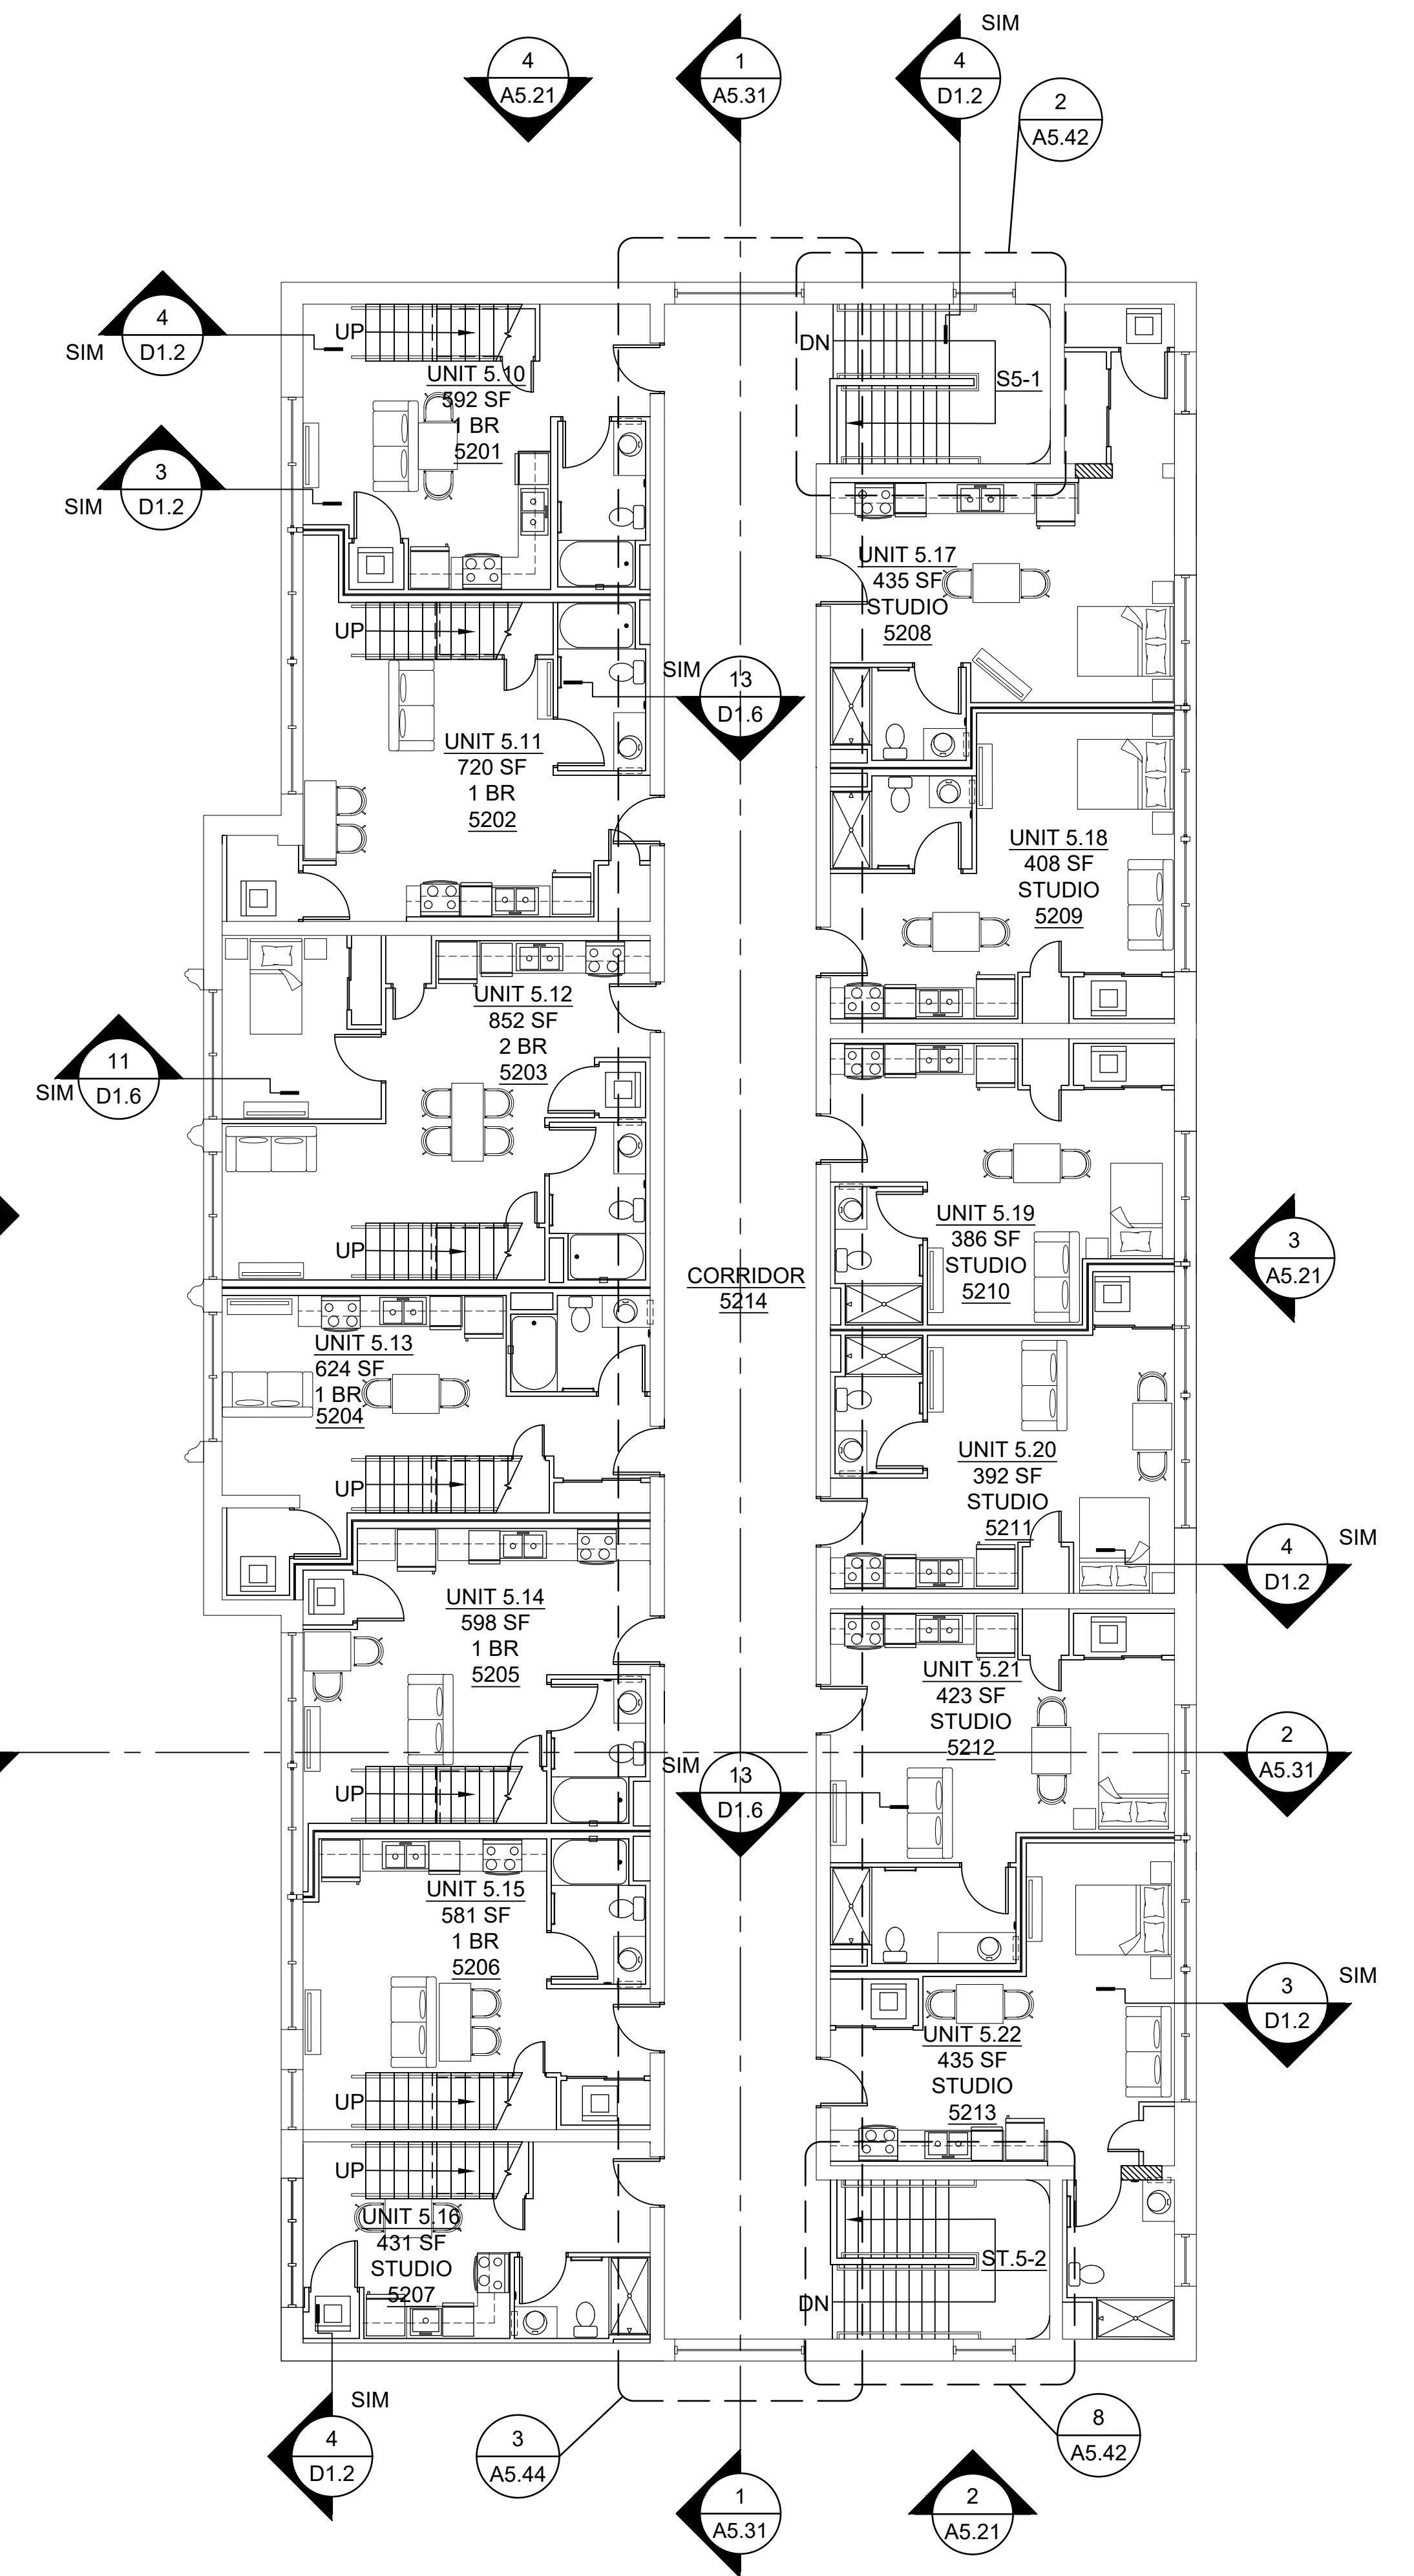

2 SECOND FLOOR PLAN
SCALE: 1/8"=1'-0"

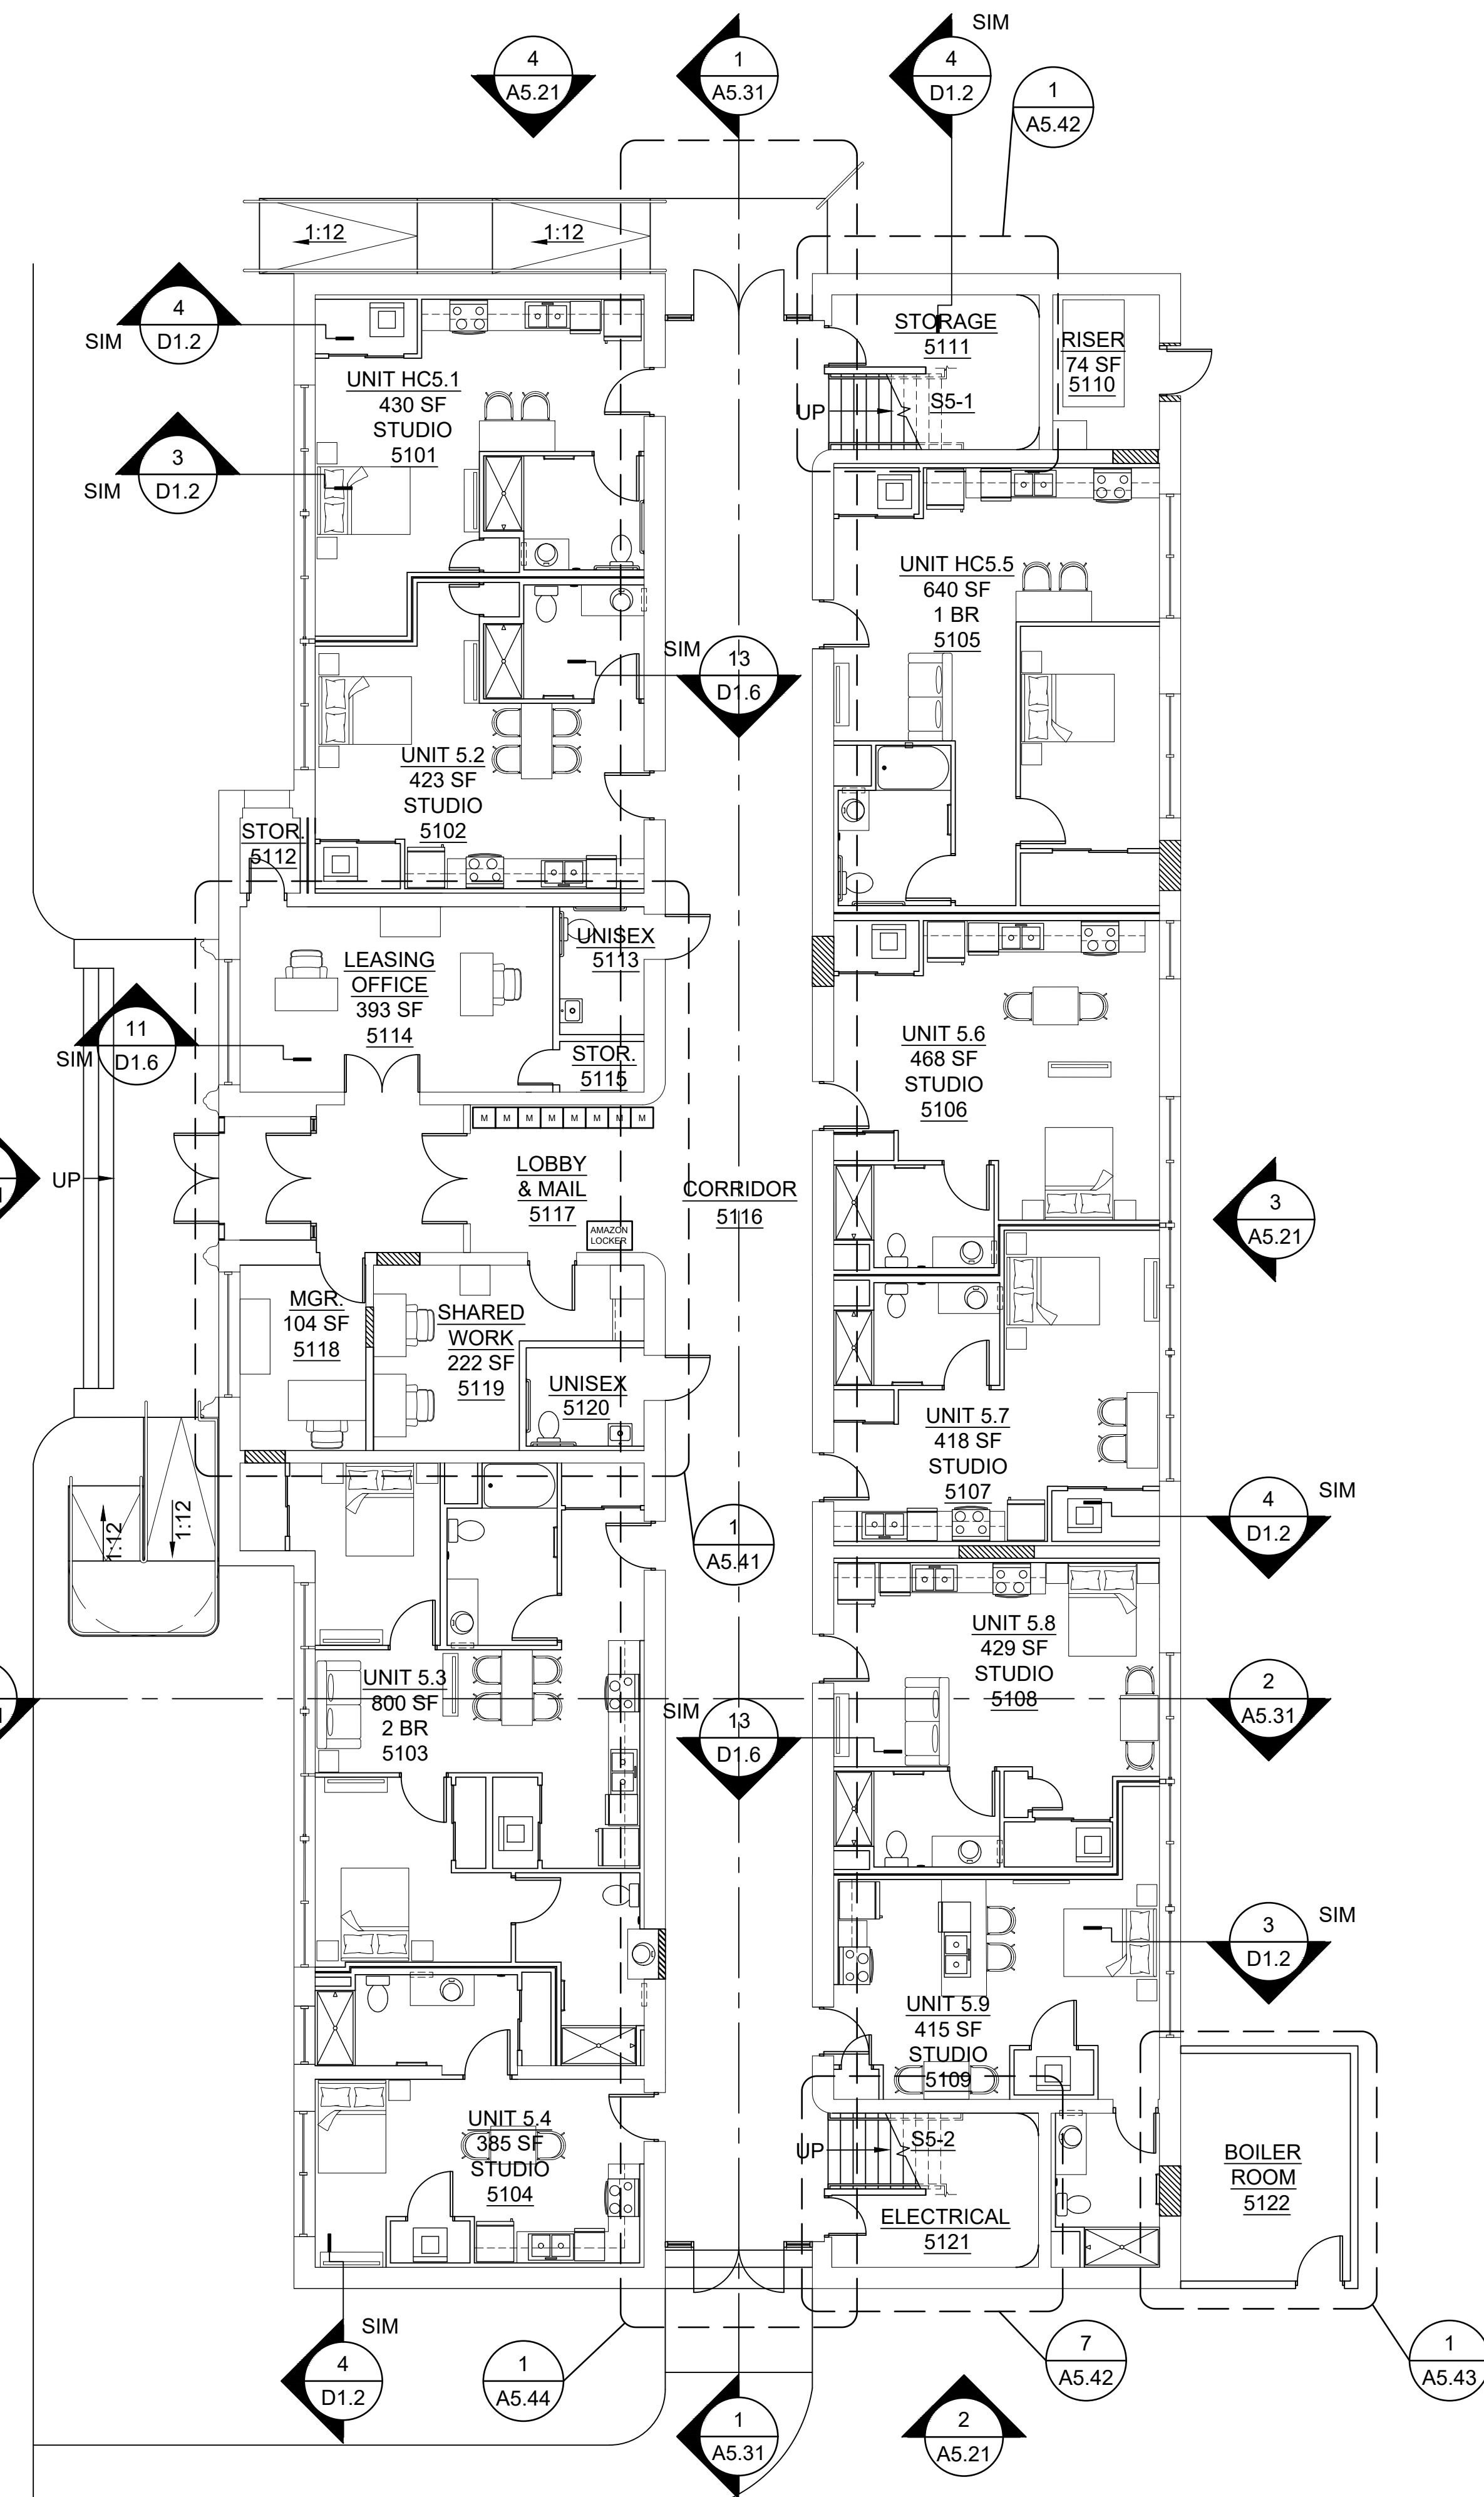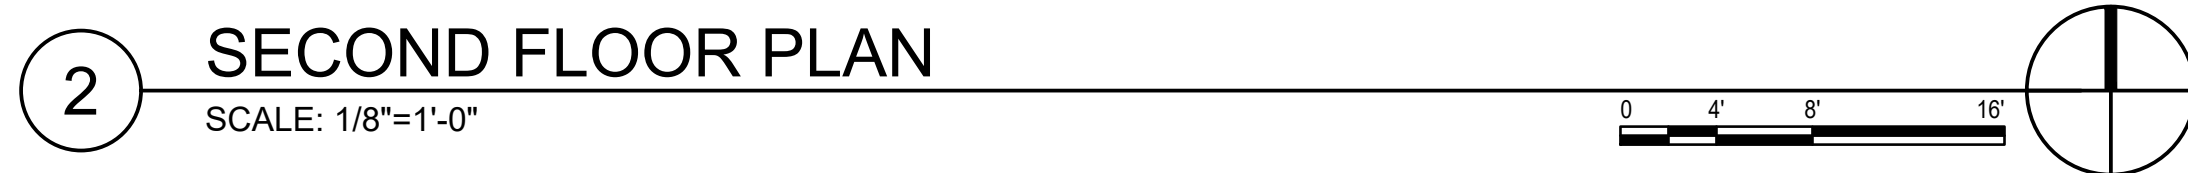

1 GROUND FLOOR PLAN
SCALE: 1/8"=1'-0"

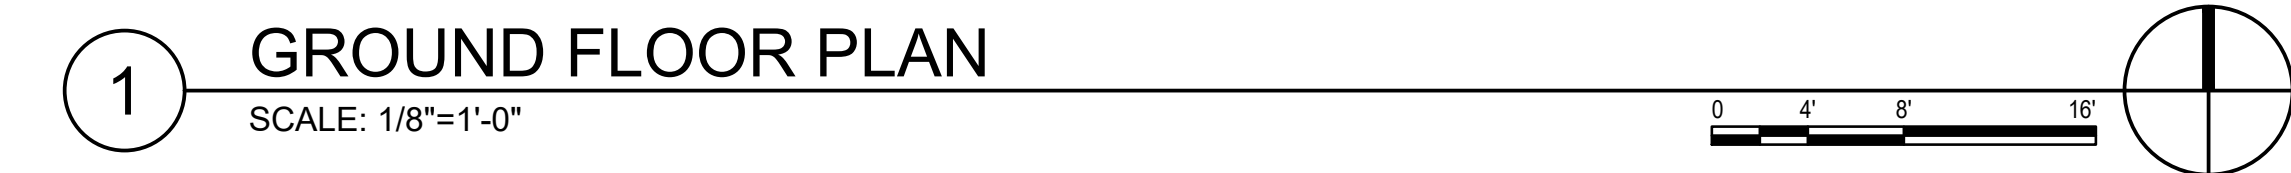

GENERAL NOTES

- PROTECT ALL EXISTING FINISHES AND MATERIALS TO REMAIN.
- COORDINATE SEQUENCE OF OPERATIONS, SAFETY BARRICADES, INGRESS/EGRESS PATHS AND PROTECTION OF FACILITIES AND PRODUCT WITH THE OWNER TO INSURE THE OWNER'S ABILITY TO MAINTAIN BUSINESS OPERATIONS.
- REFERENCE STRUCTURAL, PLUMBING, MECHANICAL AND ELECTRICAL DRAWINGS FOR ADDITIONAL DEMOLITION REQUIREMENTS.
- COORDINATE ALL DEMOLITION WORK WITH NEW WORK.

PROJ. #	23-42	FILE #	23-42 - Building 5 - Existing
REVISION		DATE	9 APR 2025
DRAWN	AK	CHECKED	AK


BUILDING 5
OVERALL PLANS

ALL-SAINTS APARTMENTS
M.C. COMPANIES
ADDRESS
TUCSON, AZ



clean alan architects plc
150 THIRD AVENUE, SUITE 301
SEATTLE, WA 98101
TELEPHONE (206) 783-4086
www.cleanalanarchitects.com

A5.11



_ OF _

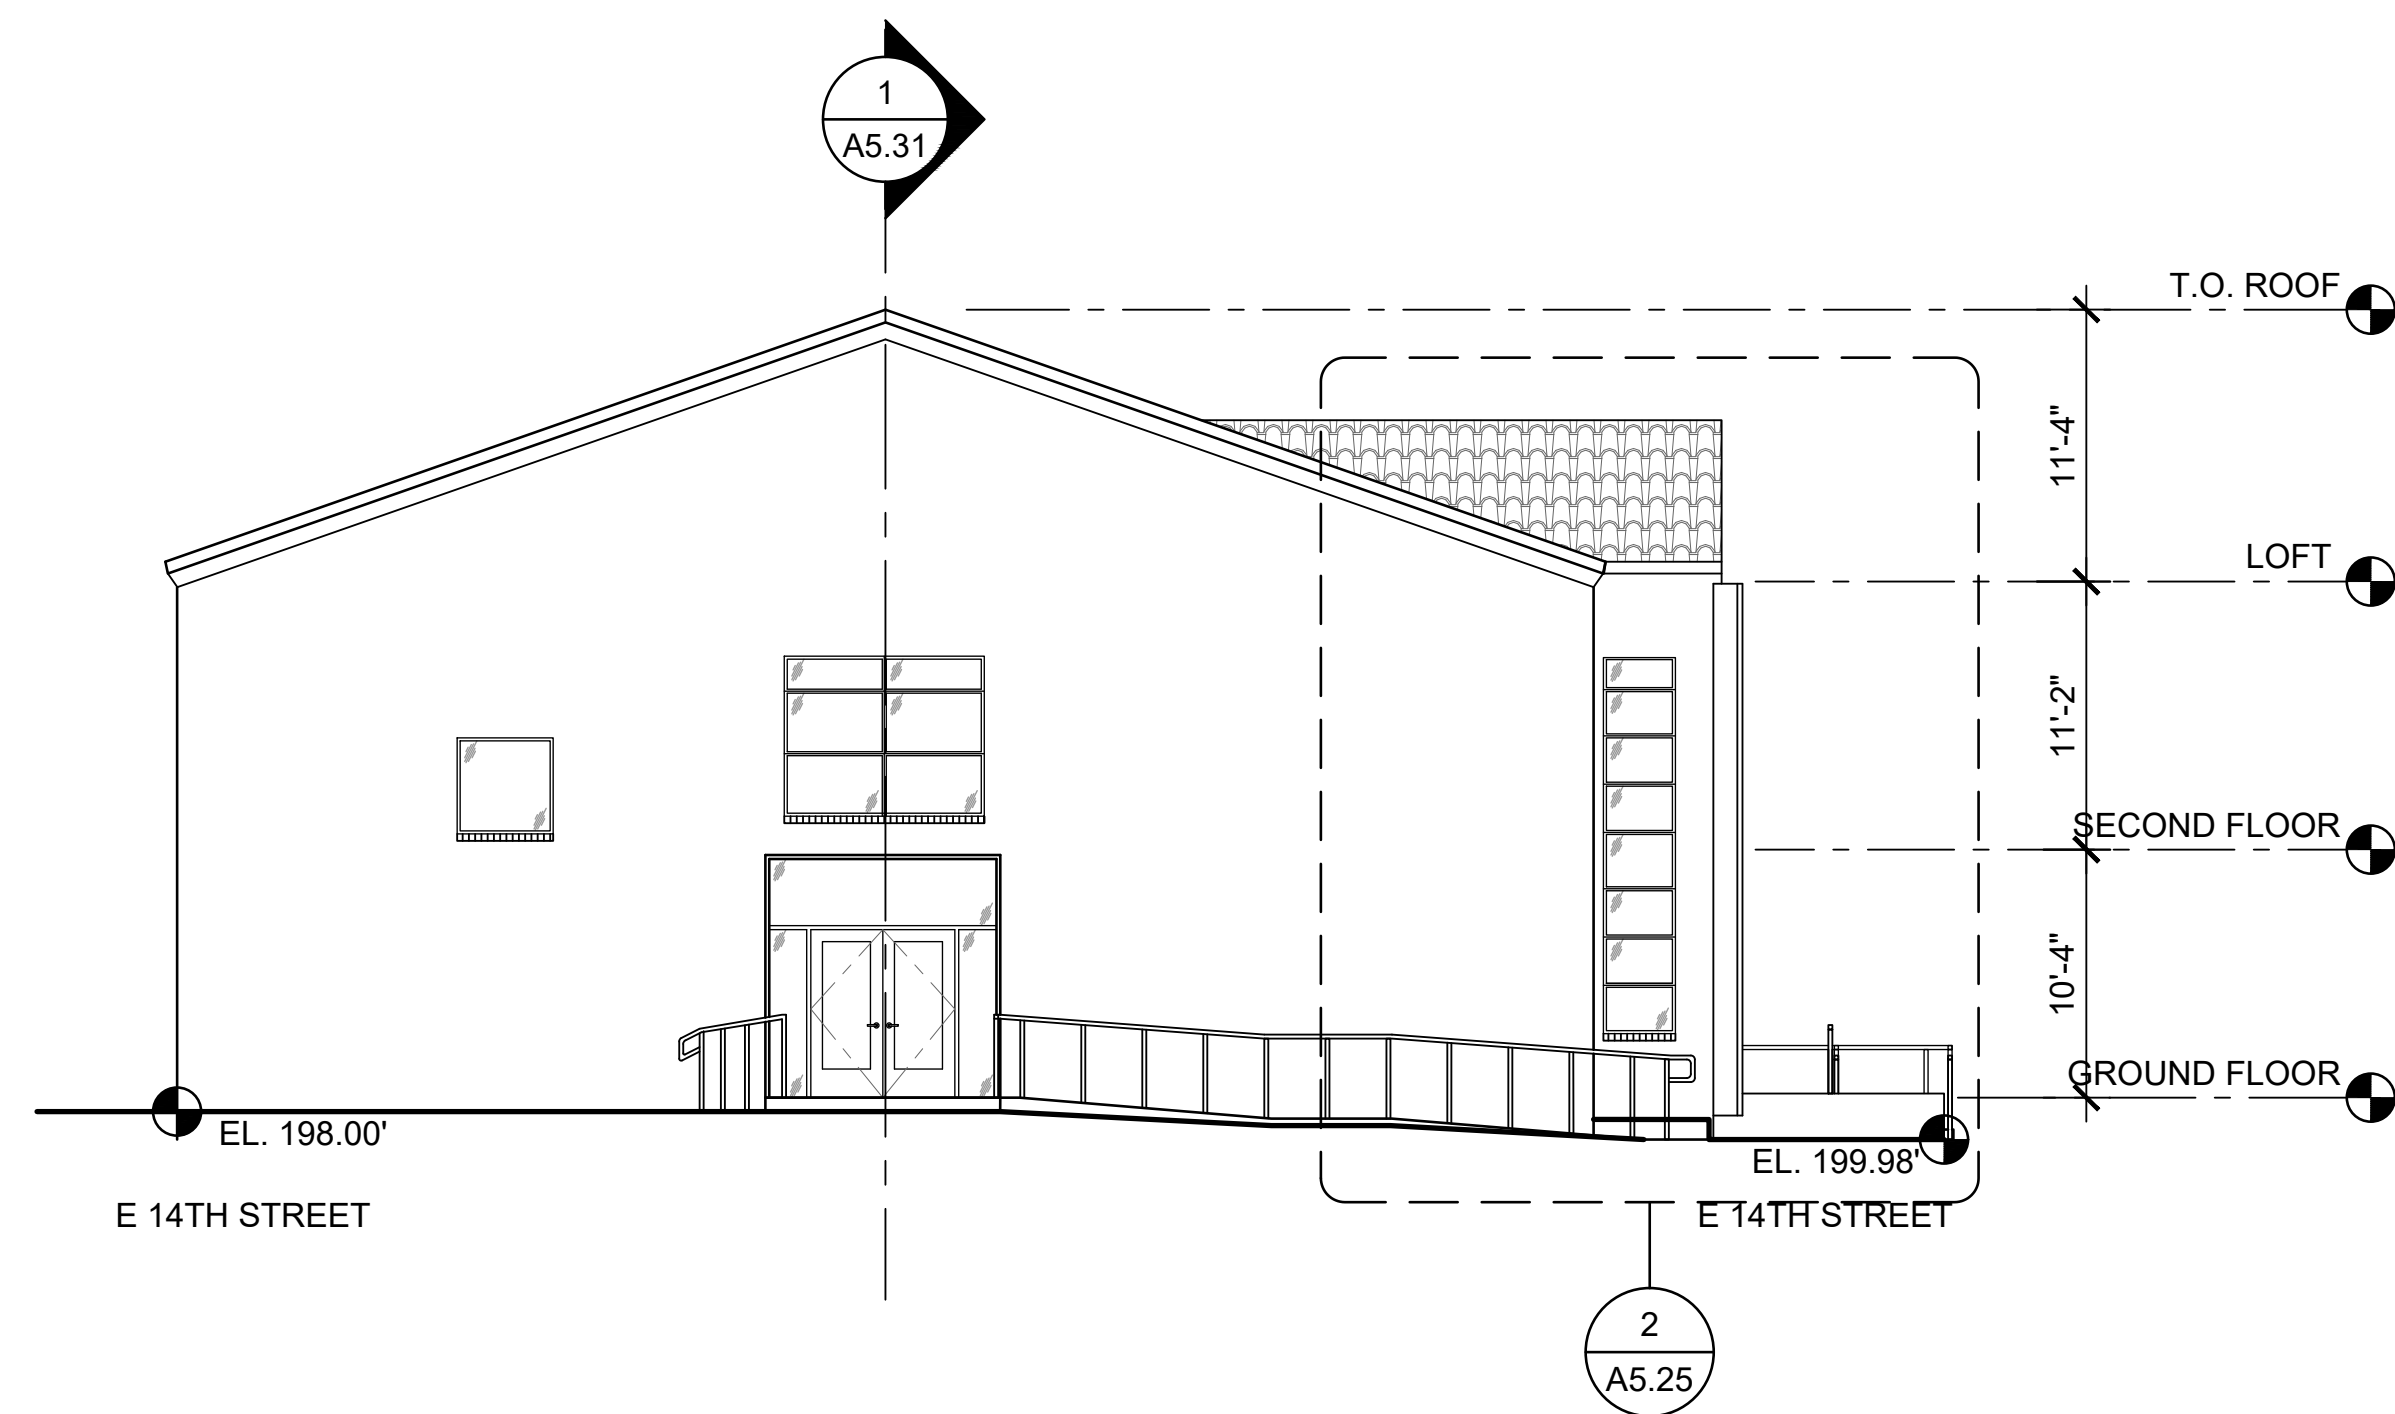


 
4 BUILDING 5 ELEVATION - NORTH
SCALE: 1/8"=1'-0"

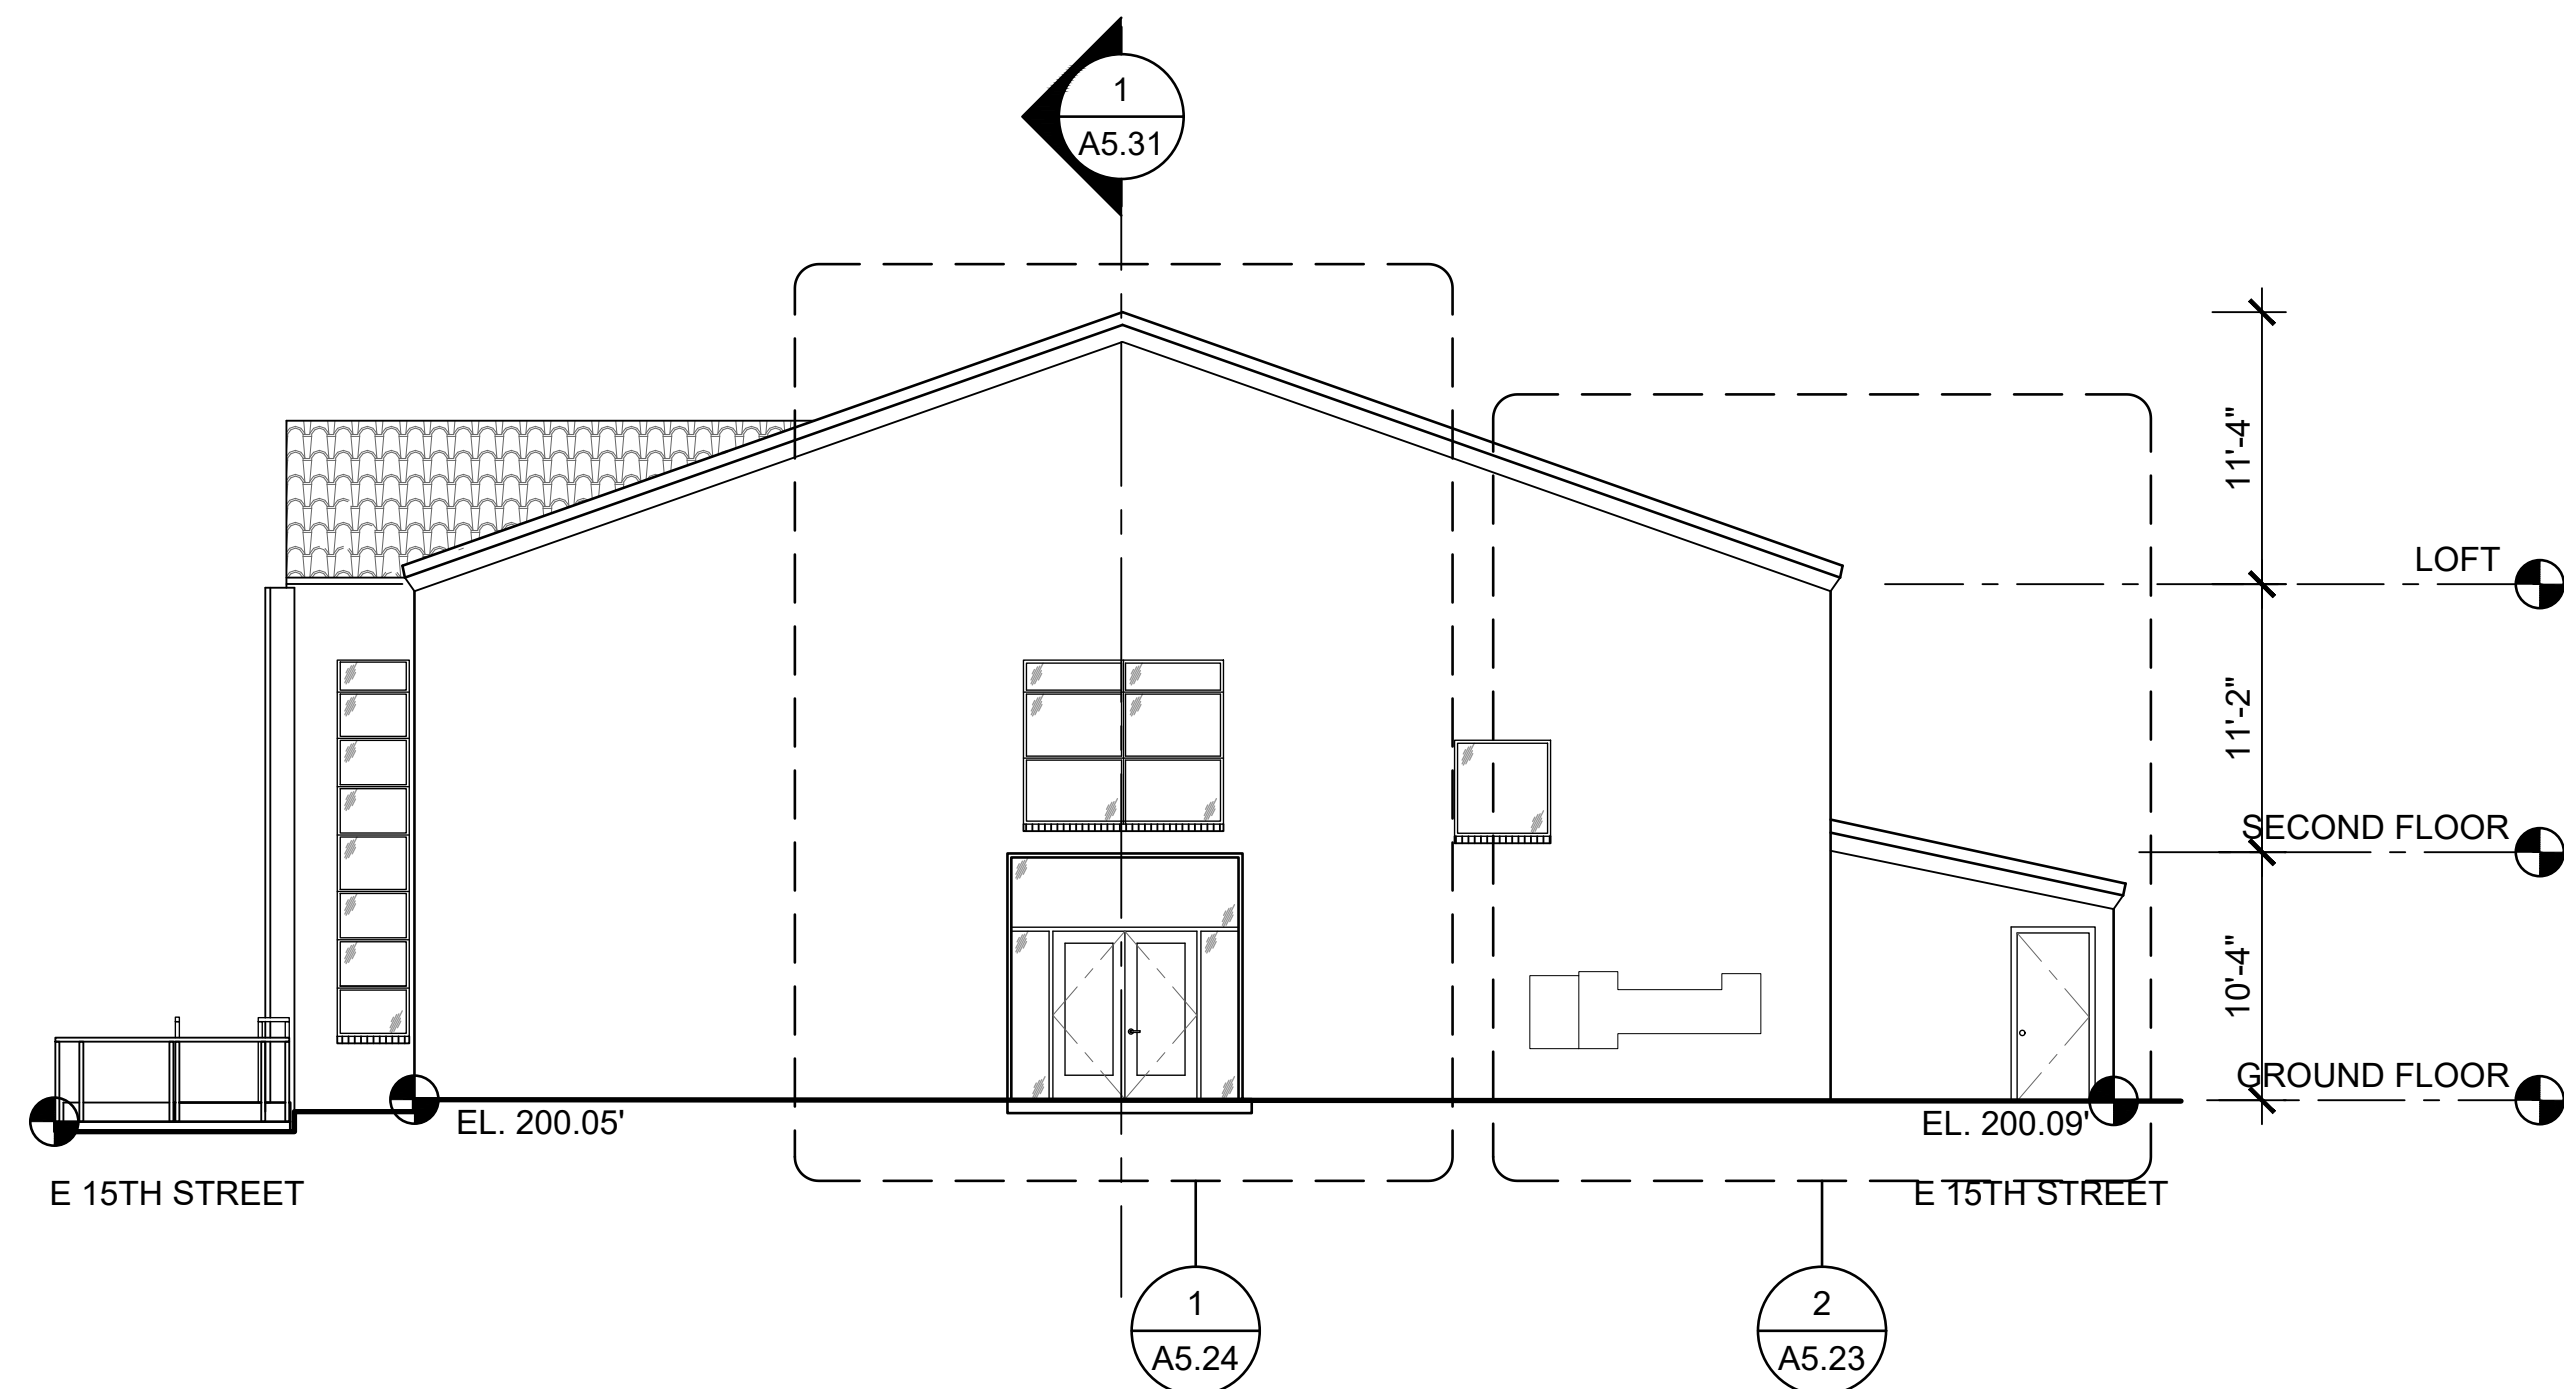

 
2 BUILDING 5 ELEVATION - SOUTH
SCALE: 1/8"=1'-0"

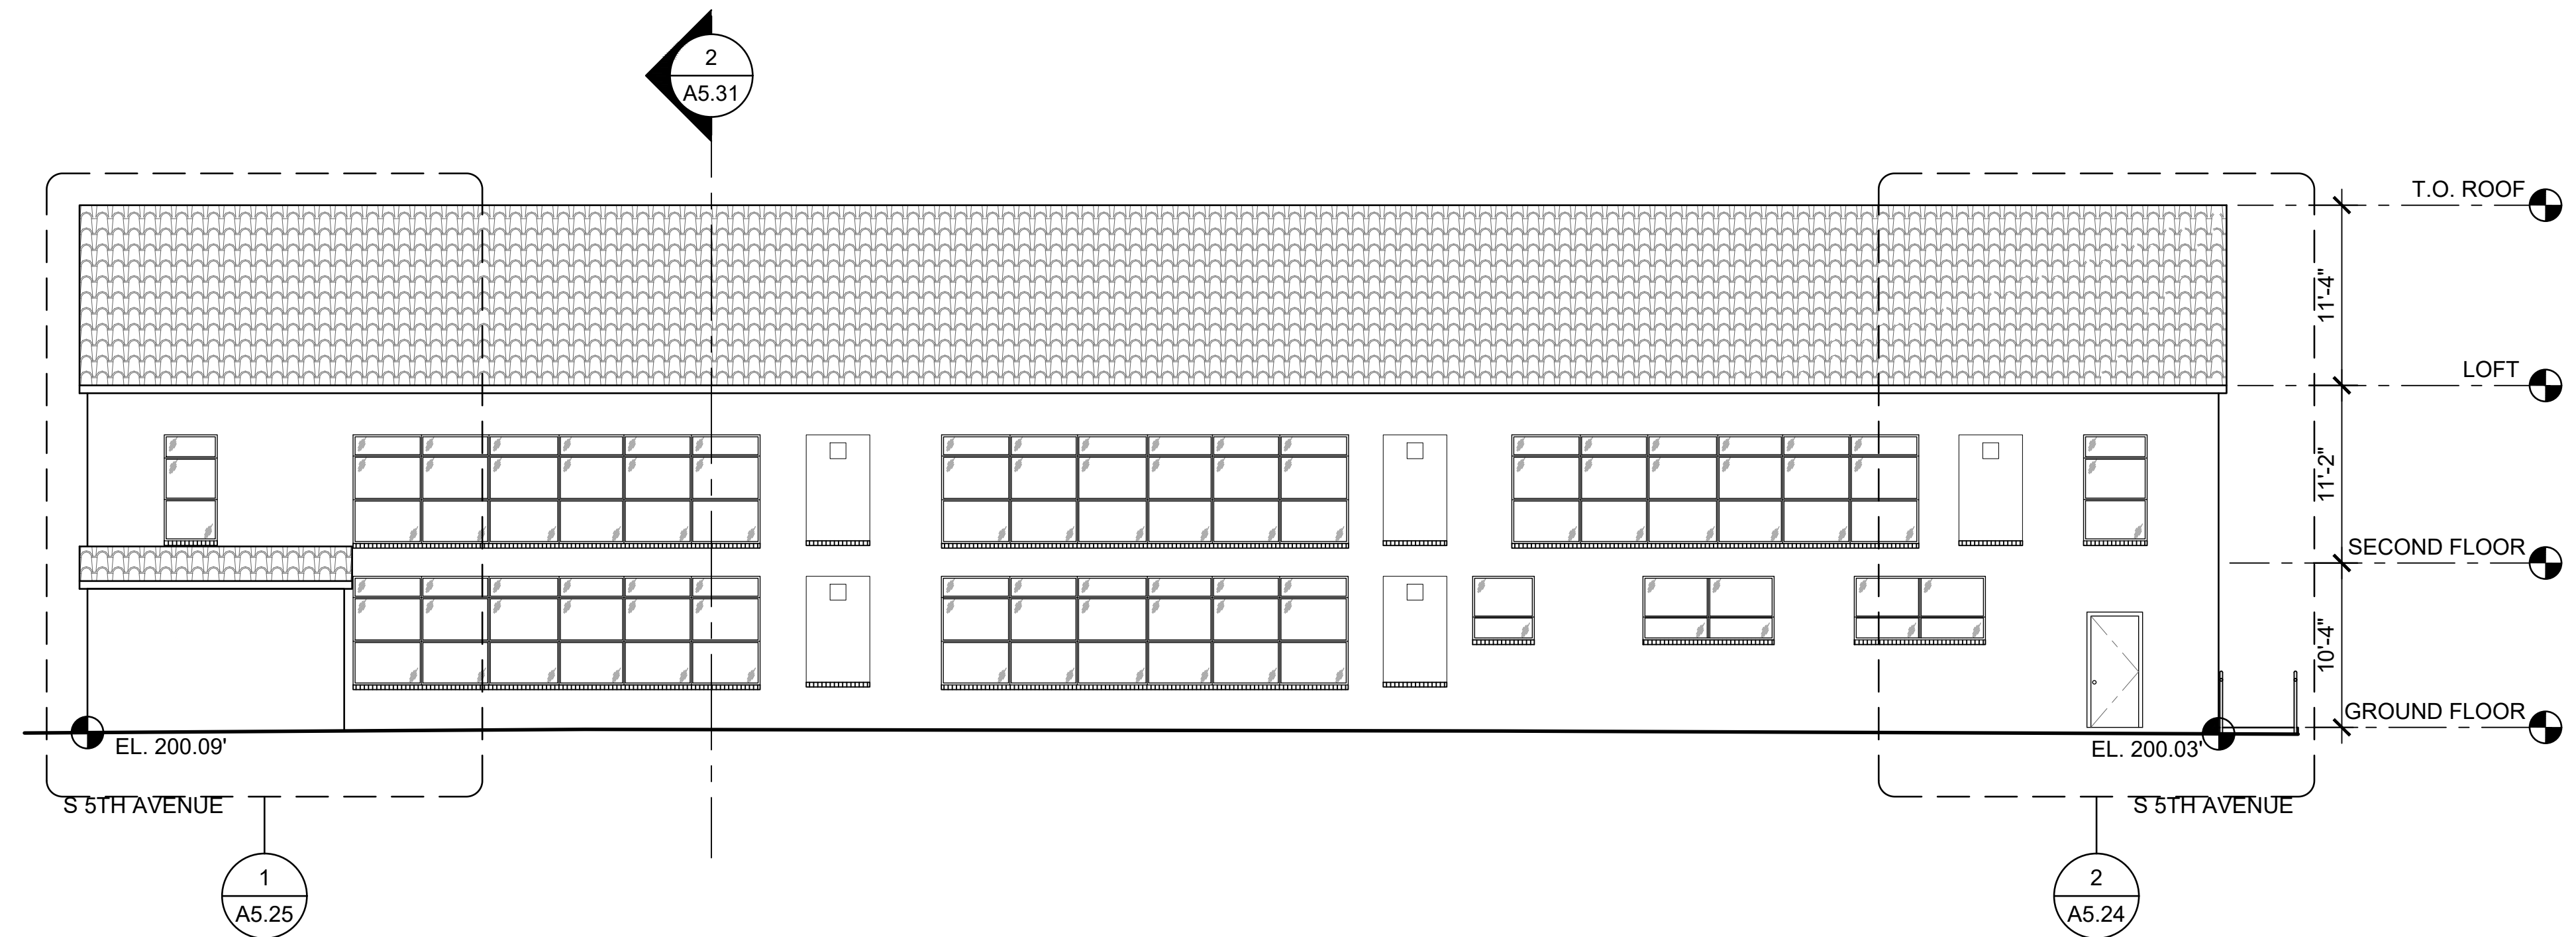

 3 BUILDING 5 ELEVATION - EAST
SCALE: 1/8"=1'-0"

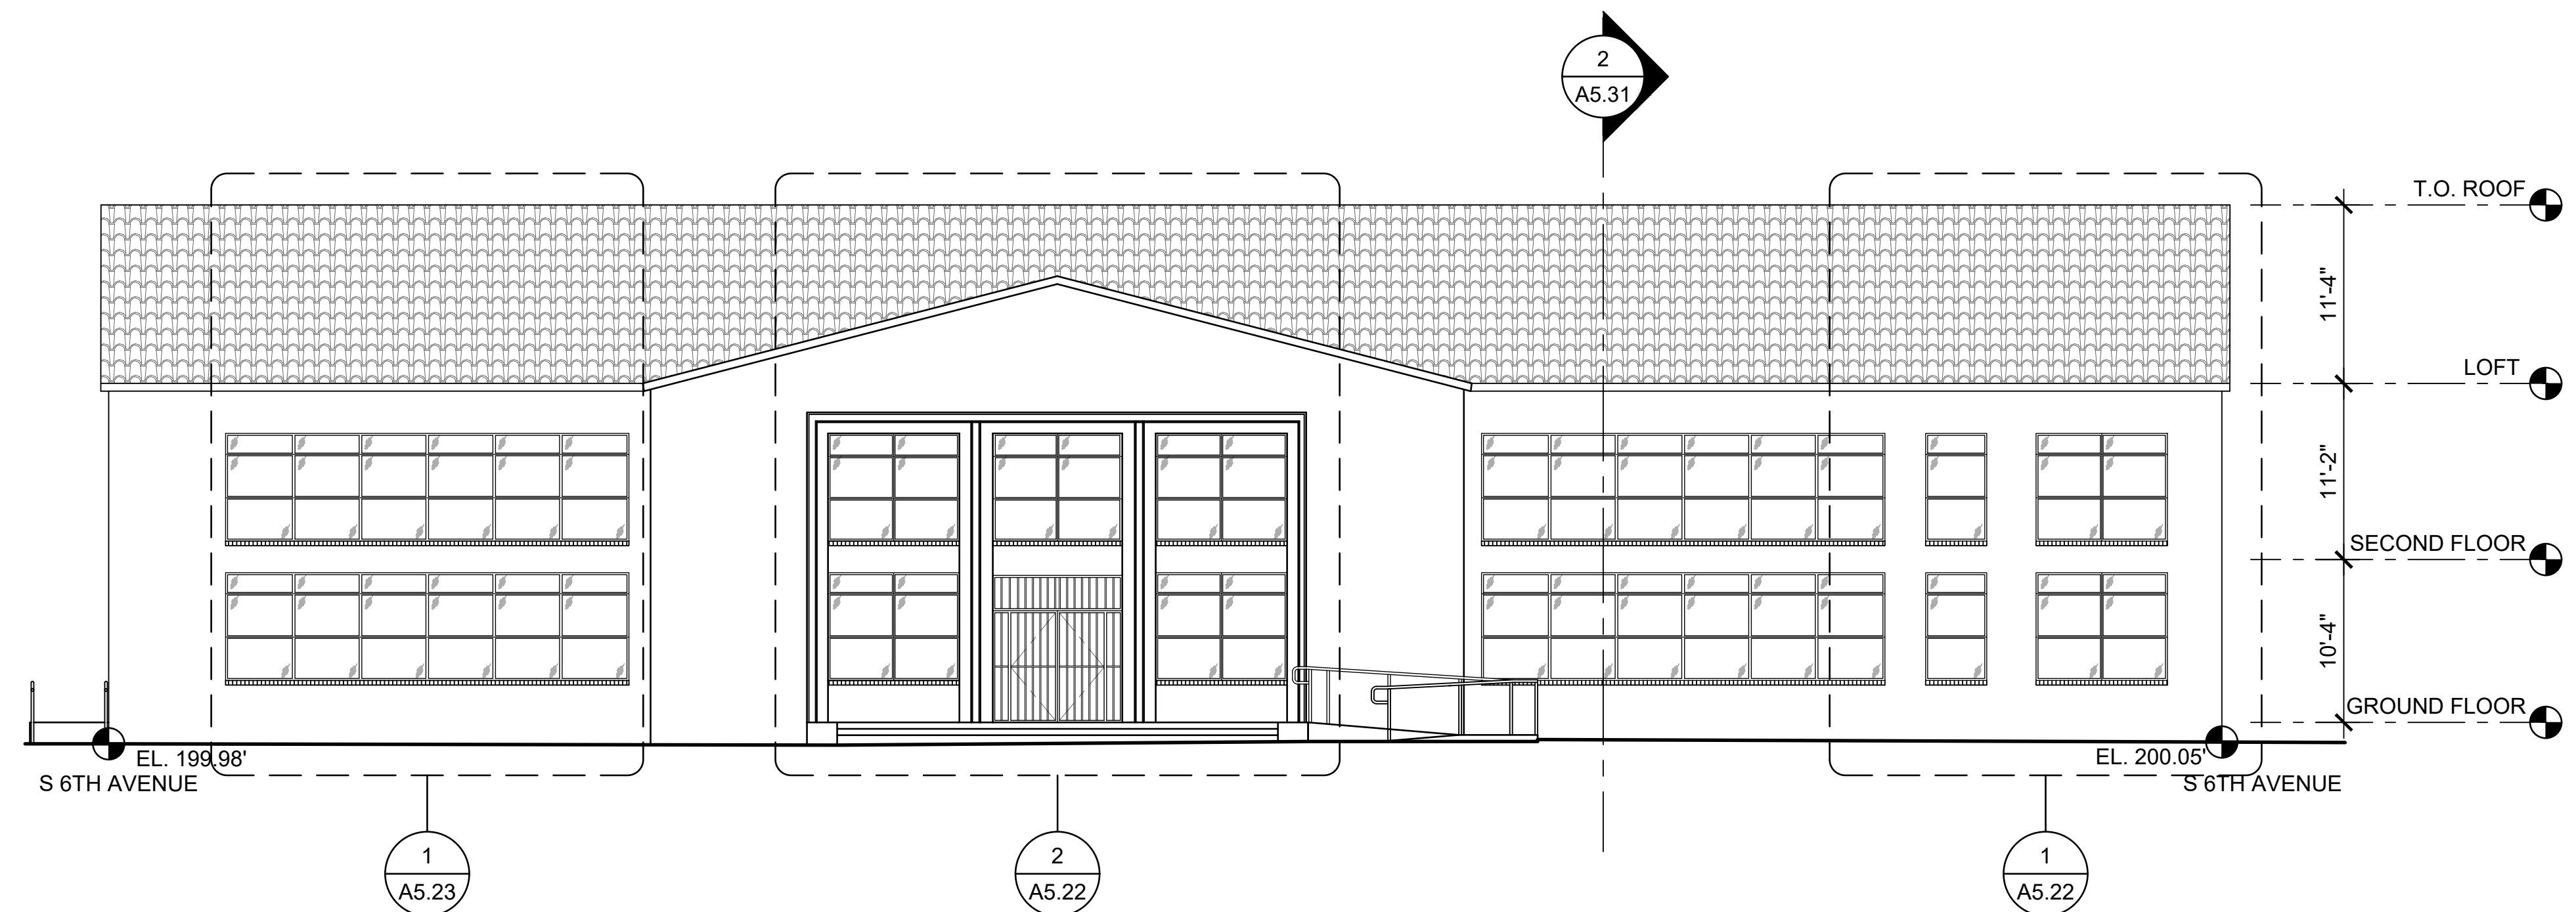

 1 BUILDING 5 ELEVATION - WEST
SCALE: 1/8"=1'-0"



PROJ. #	FILE #	23-42	23-42	Building 5 - Existing
DATE	9 APR 2025	REVISION		
DRAWN	AK	CHECKED	AK	


BUILDING 5
ELEVATIONS

ALL-SAINTS APARTMENTS
M.C. COMPANIES
ADDRESS
TUCSON, AZ



dean alan architects plc
1501 THIRD AVENUE, SUITE 301
SEATTLE, WA 98101
TELEPHONE (206) 783-4086
www.deanalanarchitects.com

A5.21


_ OF _

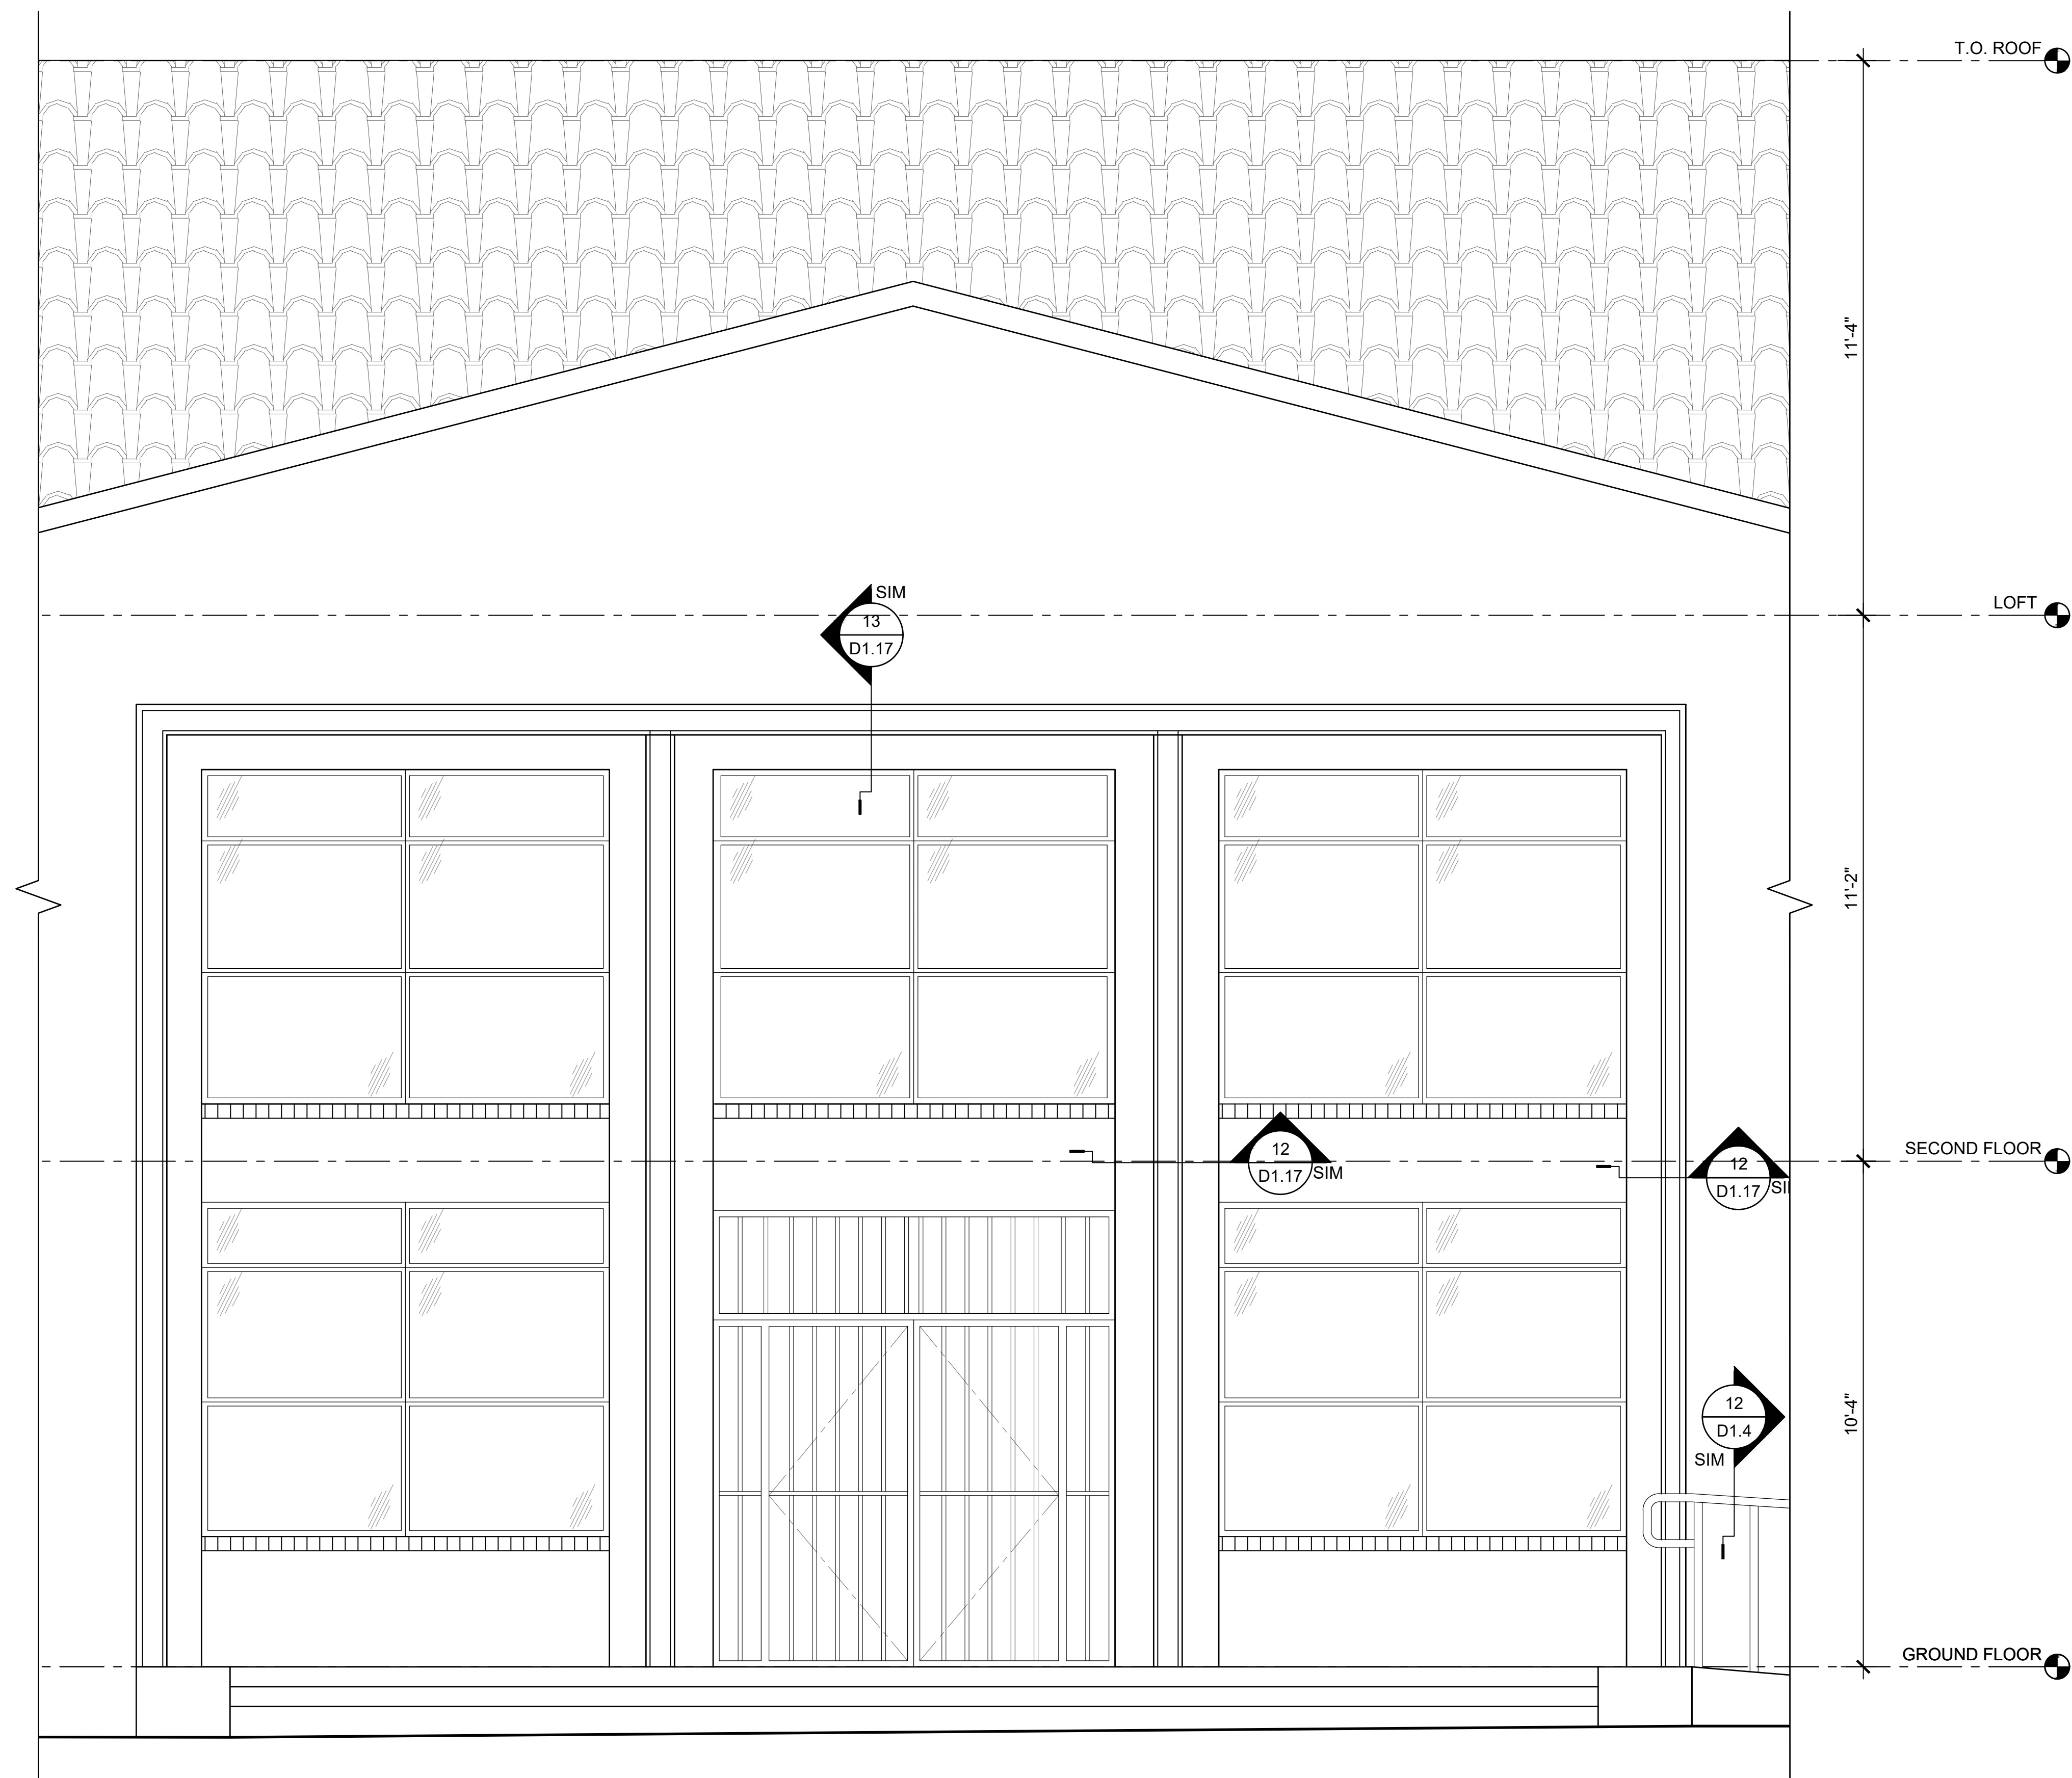

 2 BUILDING 5 ELEVATION - WEST
SCALE: 1/2"=1'-0"

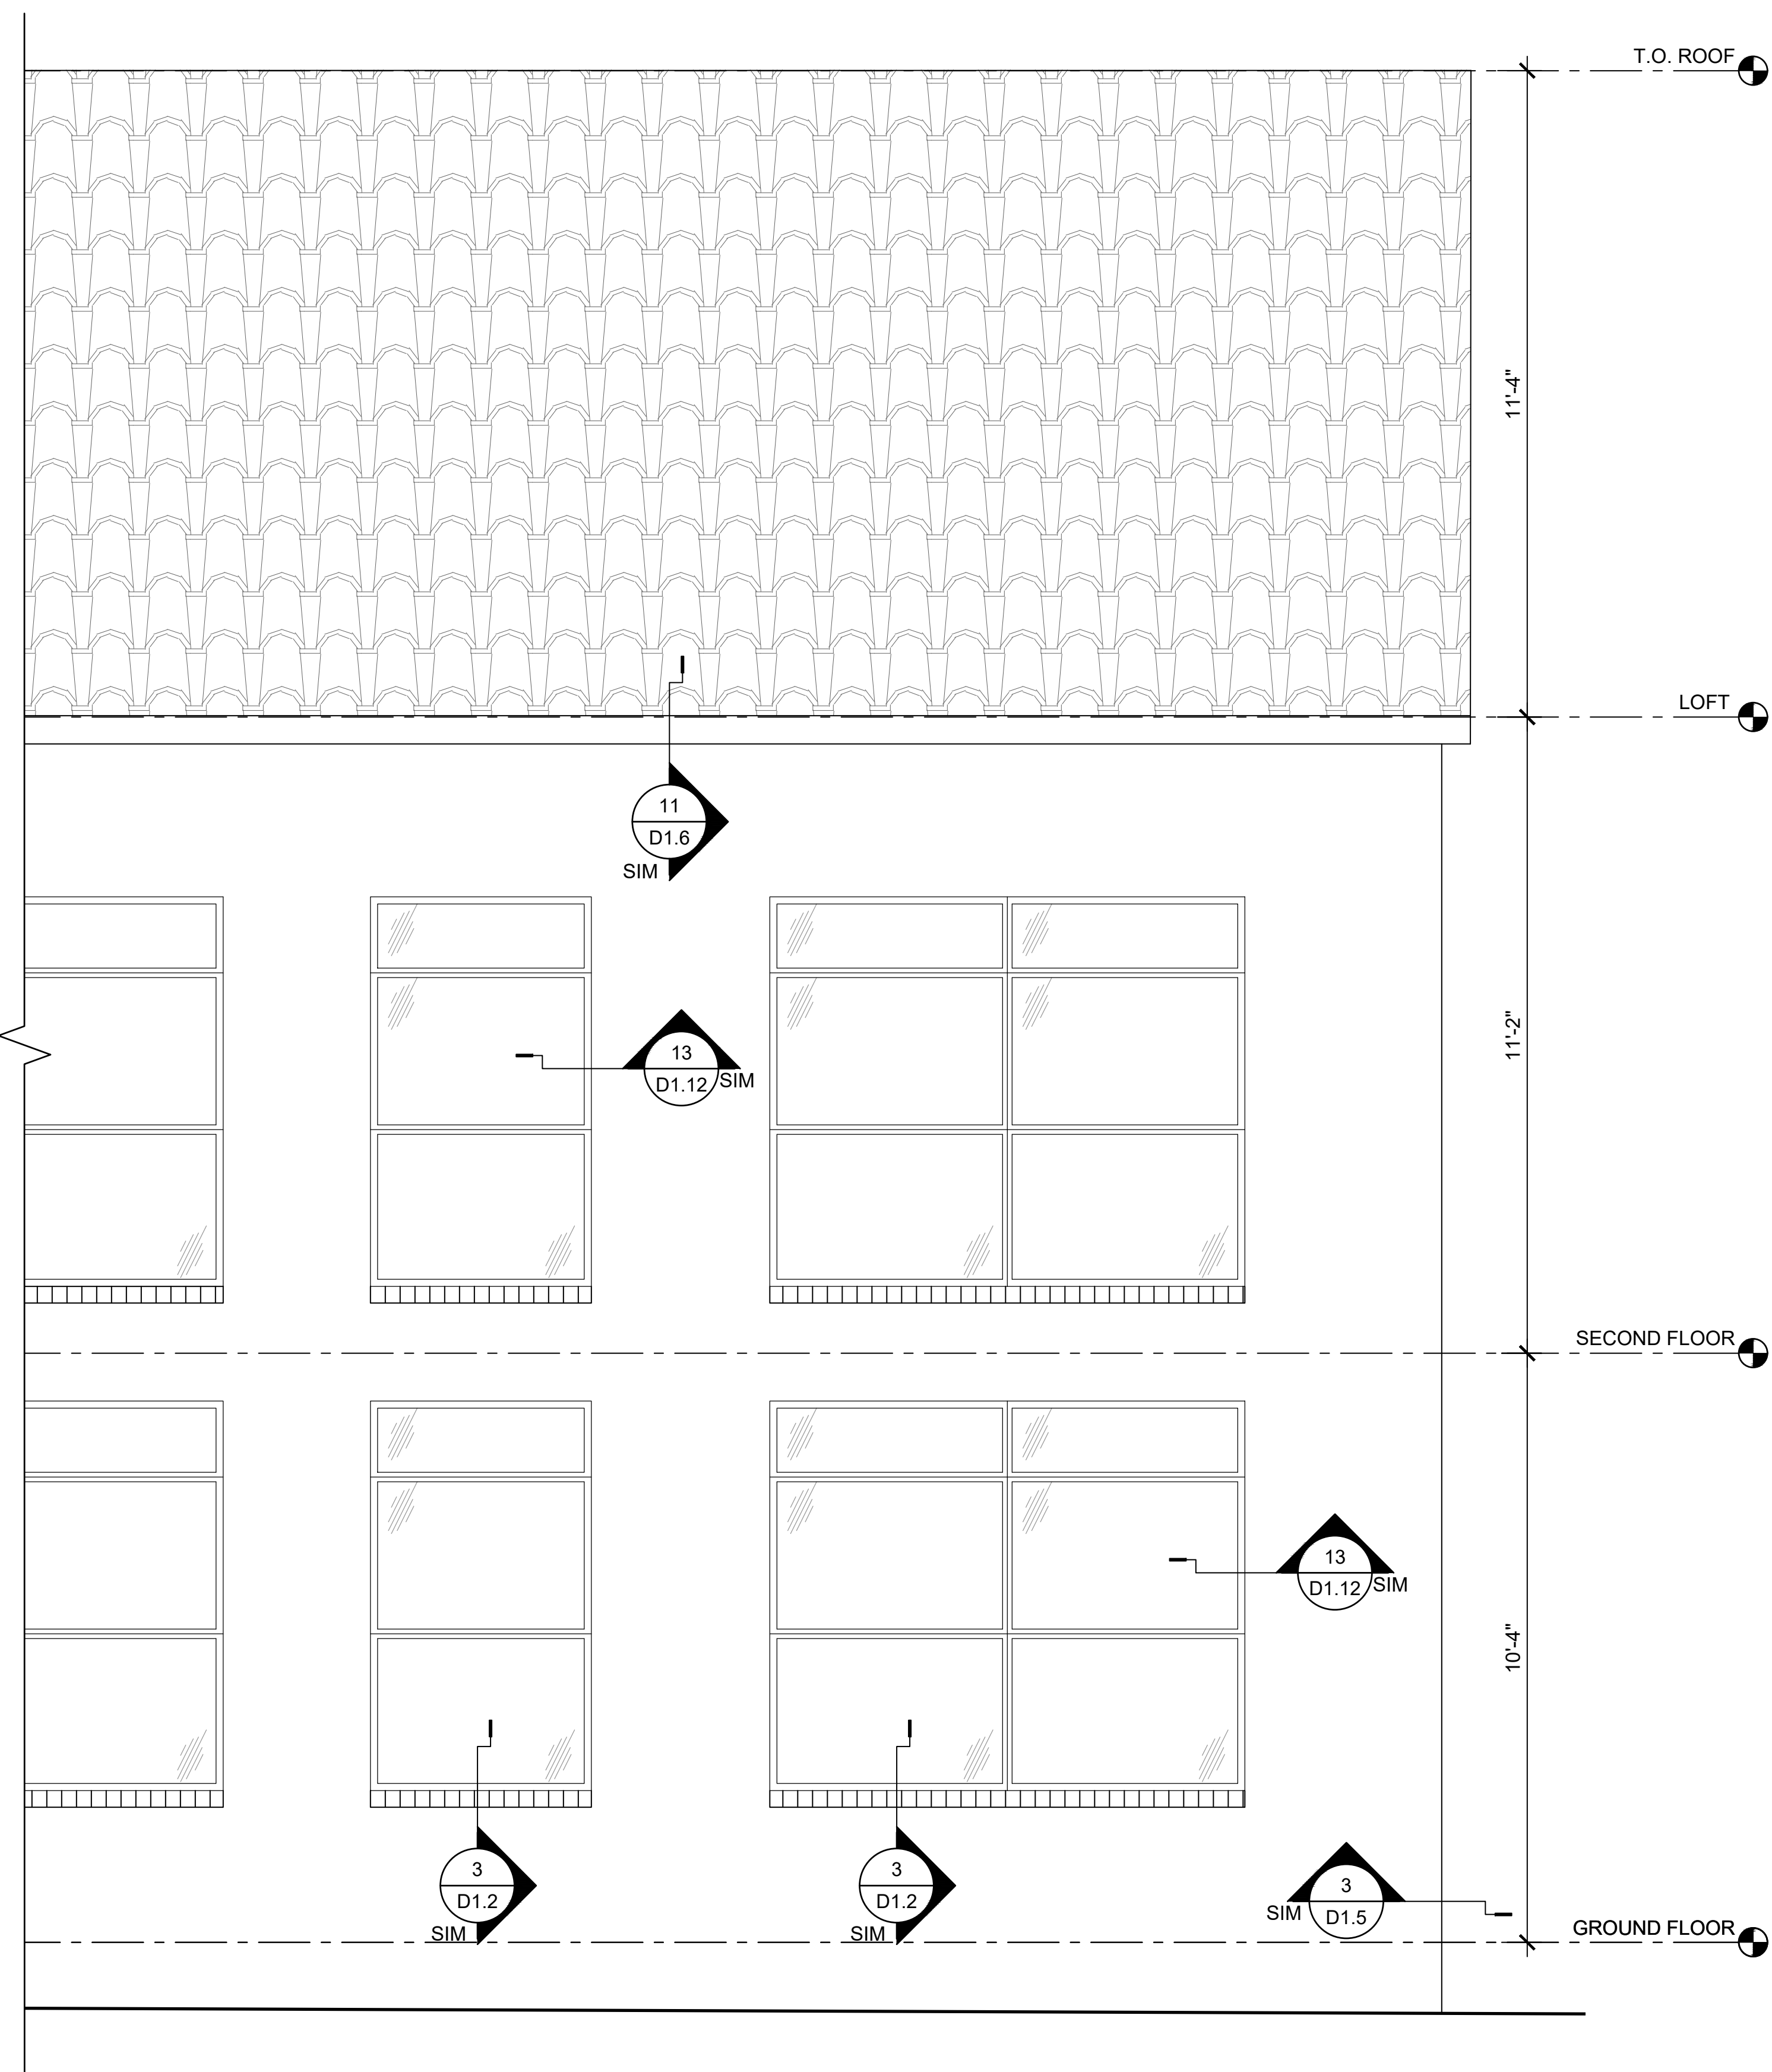

 1 BUILDING 5 ELEVATION - WEST
SCALE: 1/2"=1'-0"



PROJ. #	FILE #	23-42	23-42	Building 5 - Existing
DATE	9 APR 2025	REVISION		
DRAWN	AK	CHECKED	AK	


BUILDING 5
ELEVATIONS

ALL-SAINTS APARTMENTS
M.C. COMPANIES
ADDRESS
TUCSON, AZ



clean alan architects plc
150 THIRD AVENUE, SUITE 301
SEATTLE, WA 98101
TELEPHONE (206) 783-4086
www.cleanalanarchitects.com

A5.22


_ OF _

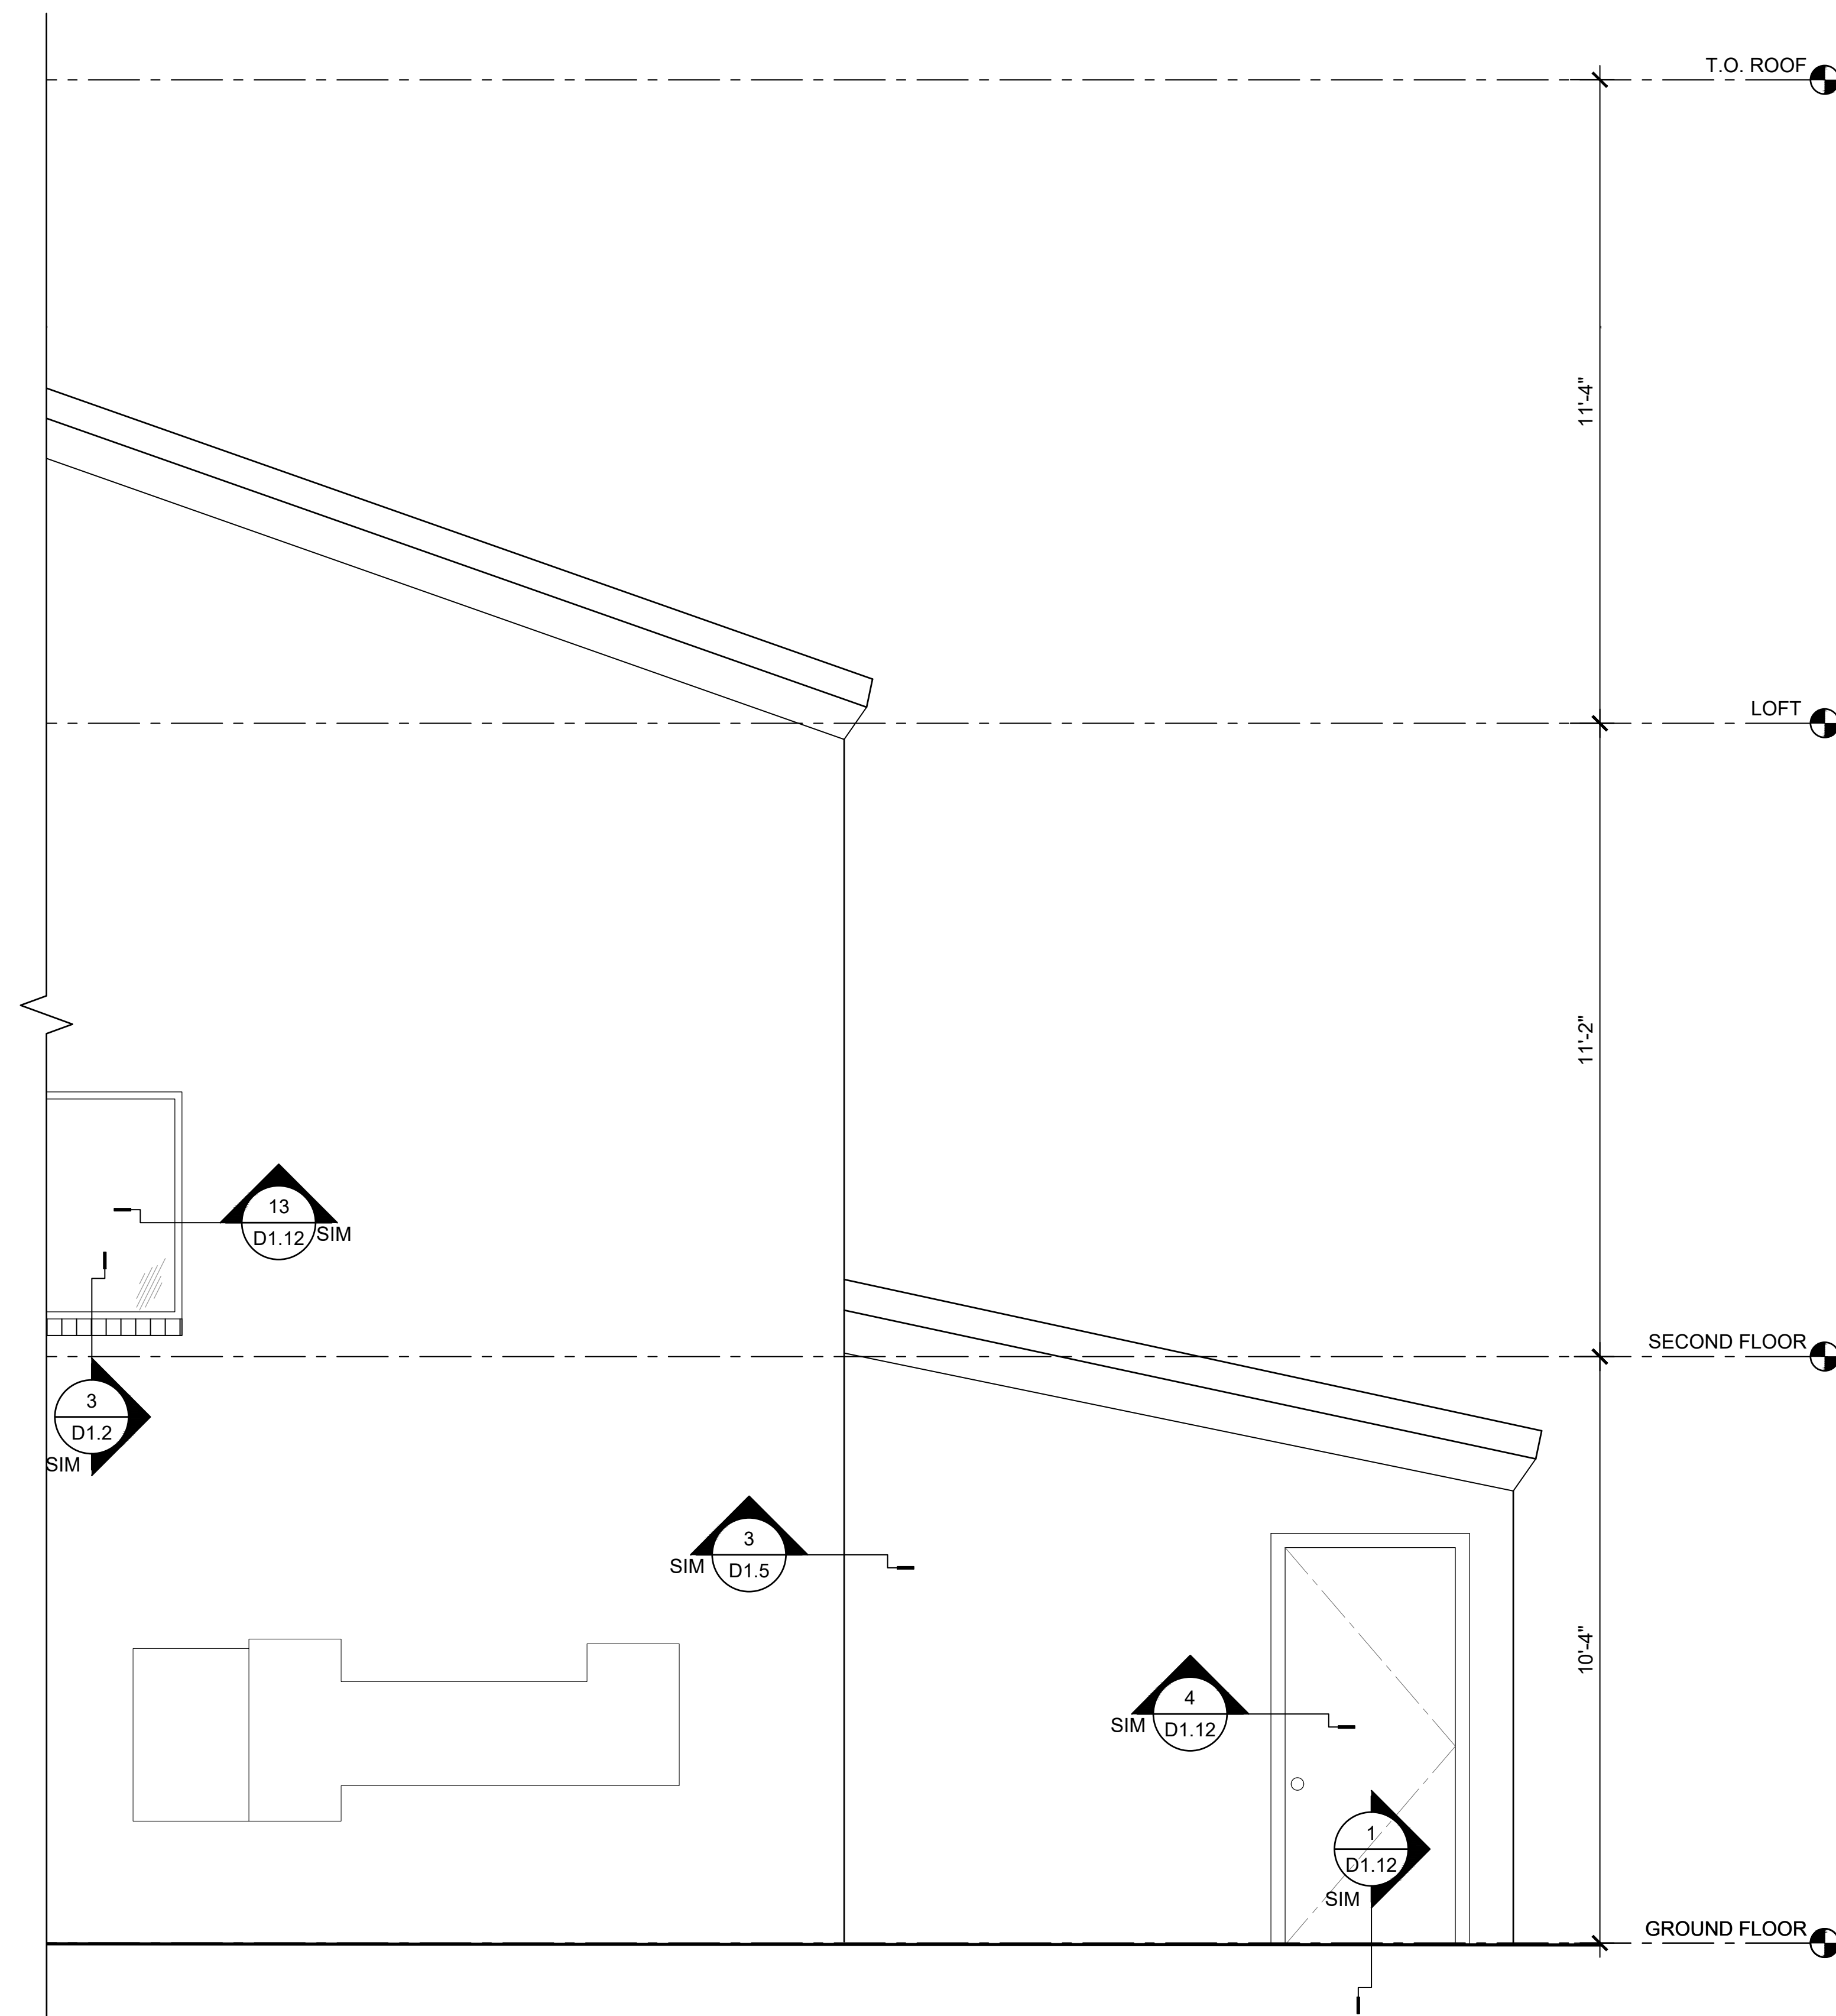

 2 BUILDING 5 ELEVATION - SOUTH
SCALE: 1/2"=1'-0"

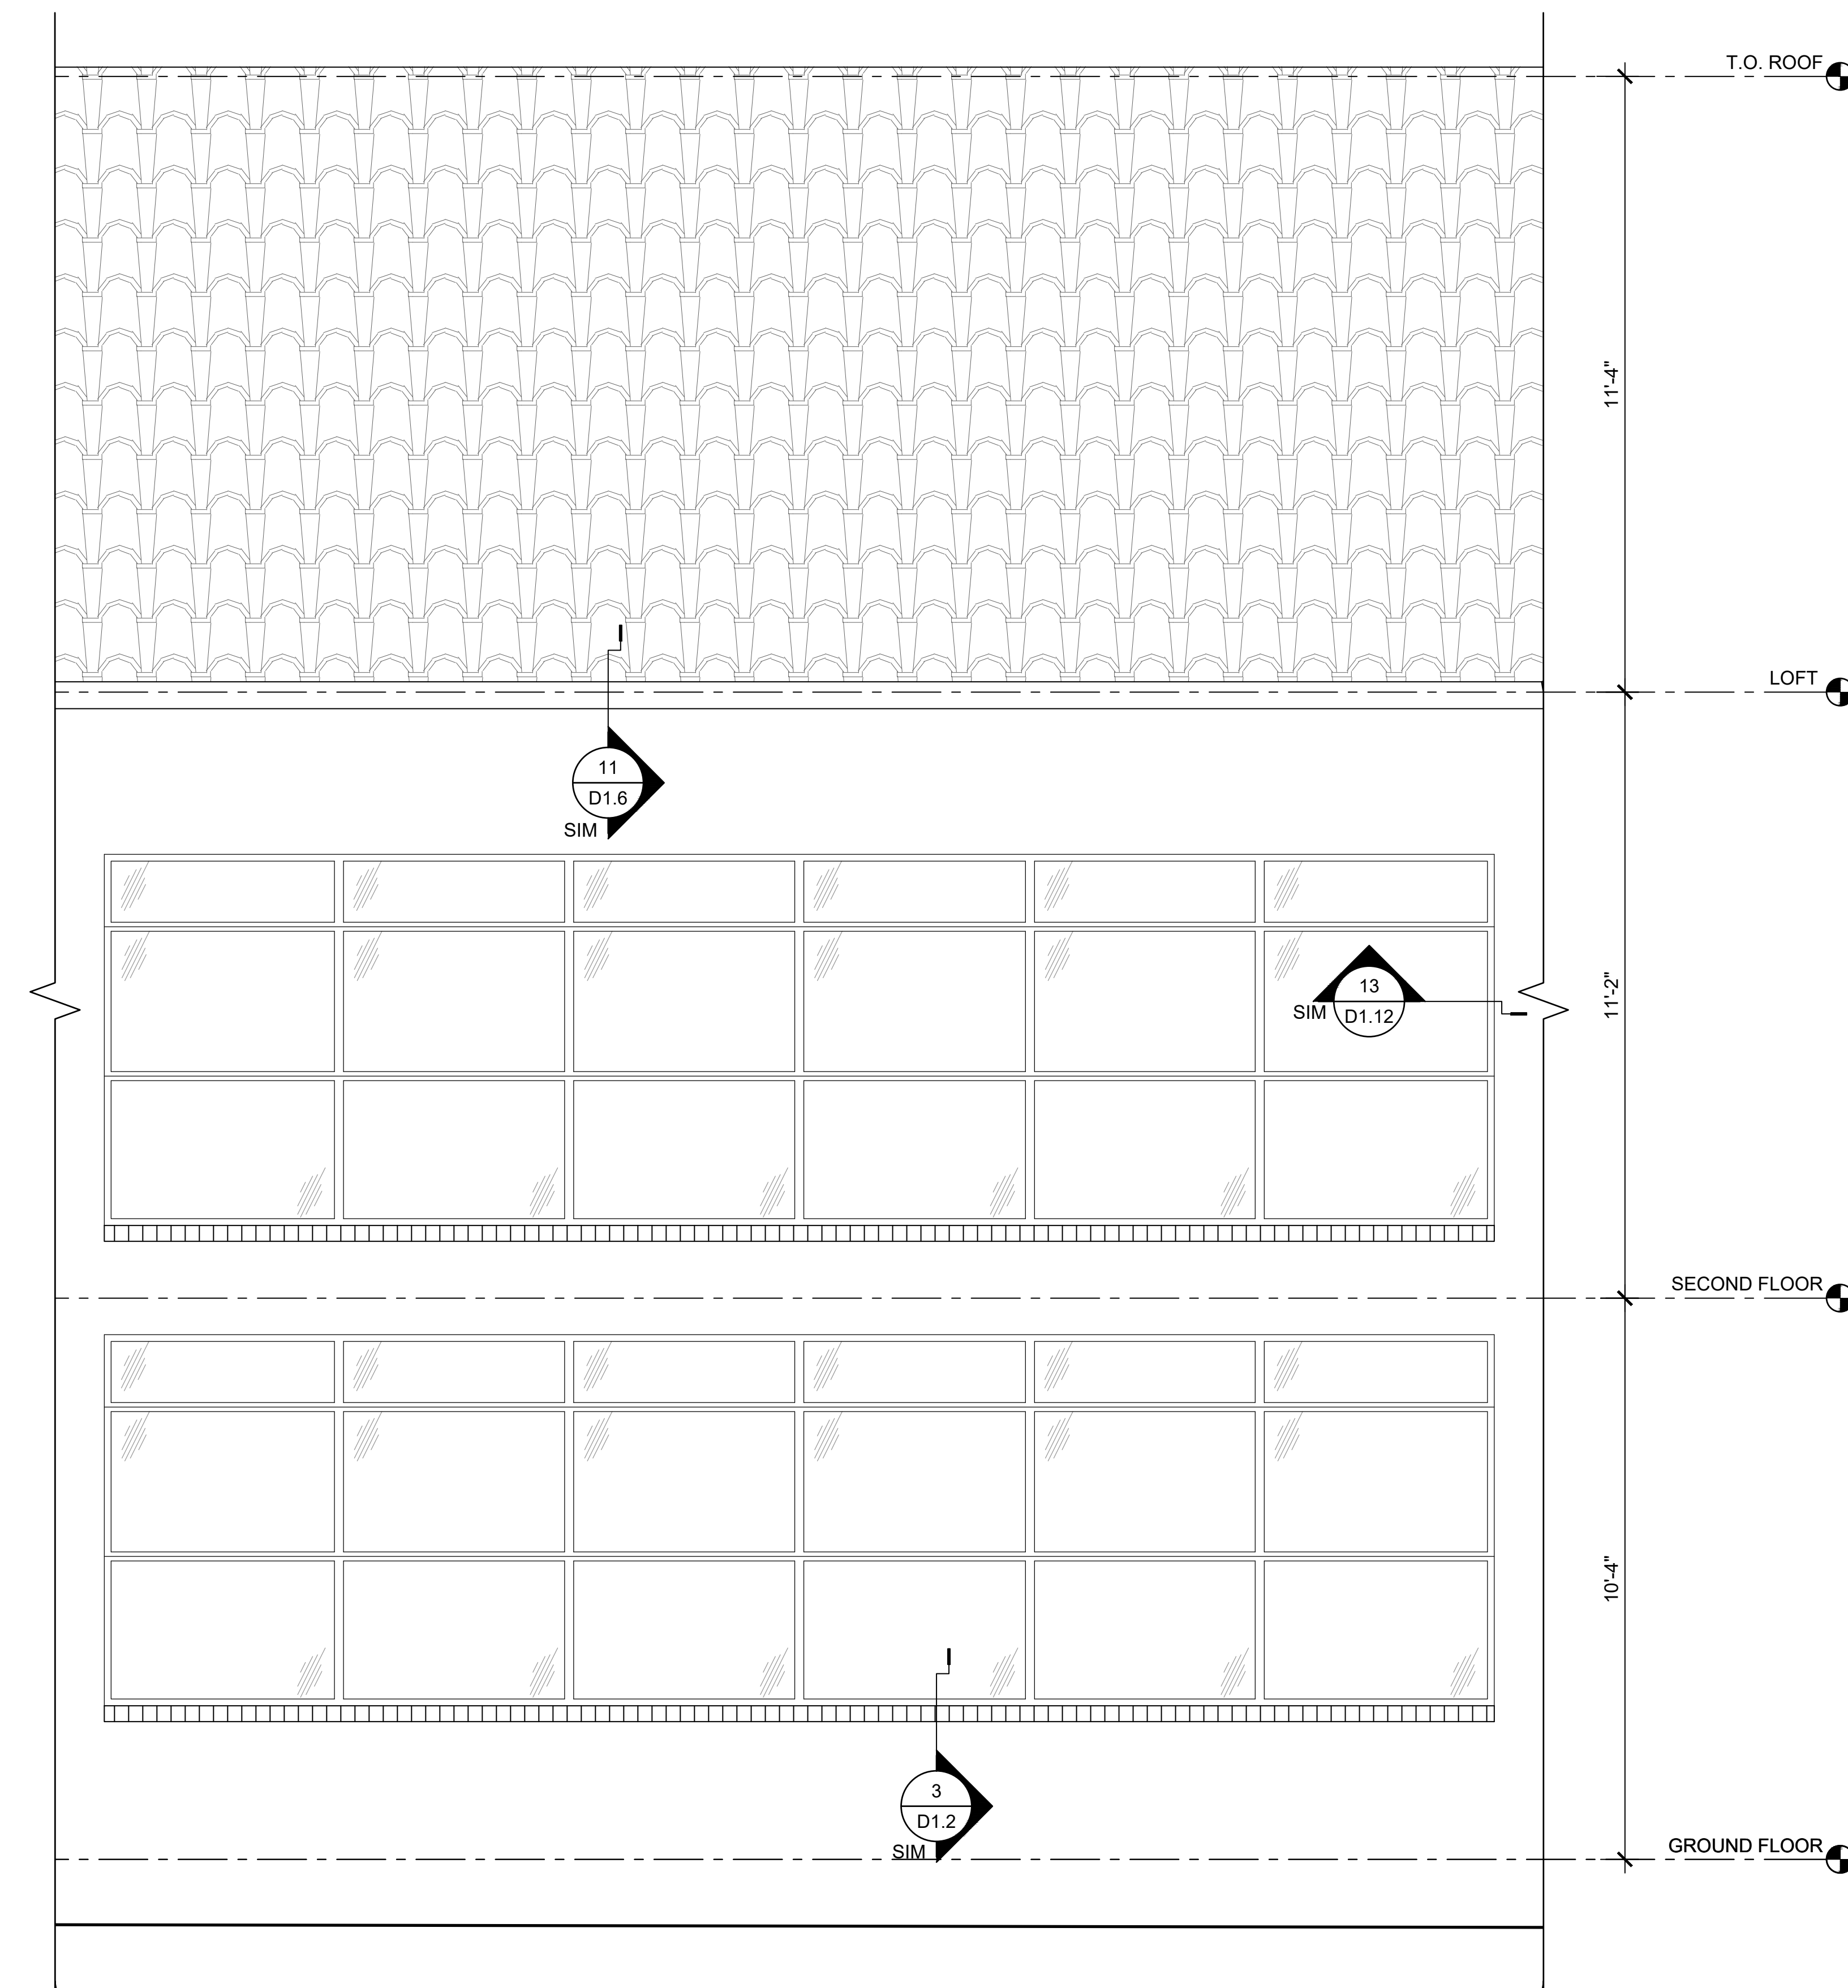

 1 BUILDING 5 ELEVATION - WEST
SCALE: 1/2"=1'-0"




PROJ. #	FILE #	23-42	23-42	Building 5 - Existing
DATE	9 APR 2025	REVISION		
DRAWN	AK	CHECKED	AK	

BUILDING 5
ELEVATIONS



ALL-SAINTS APARTMENTS
M.C. COMPANIES
ADDRESS
TUCSON, AZ

clean alan architects plc
150 THIRD AVENUE, SUITE 301
SEATTLE, WA 98101
TELEPHONE (206) 783-4086
www.cleanalanarchitects.com


A5.23

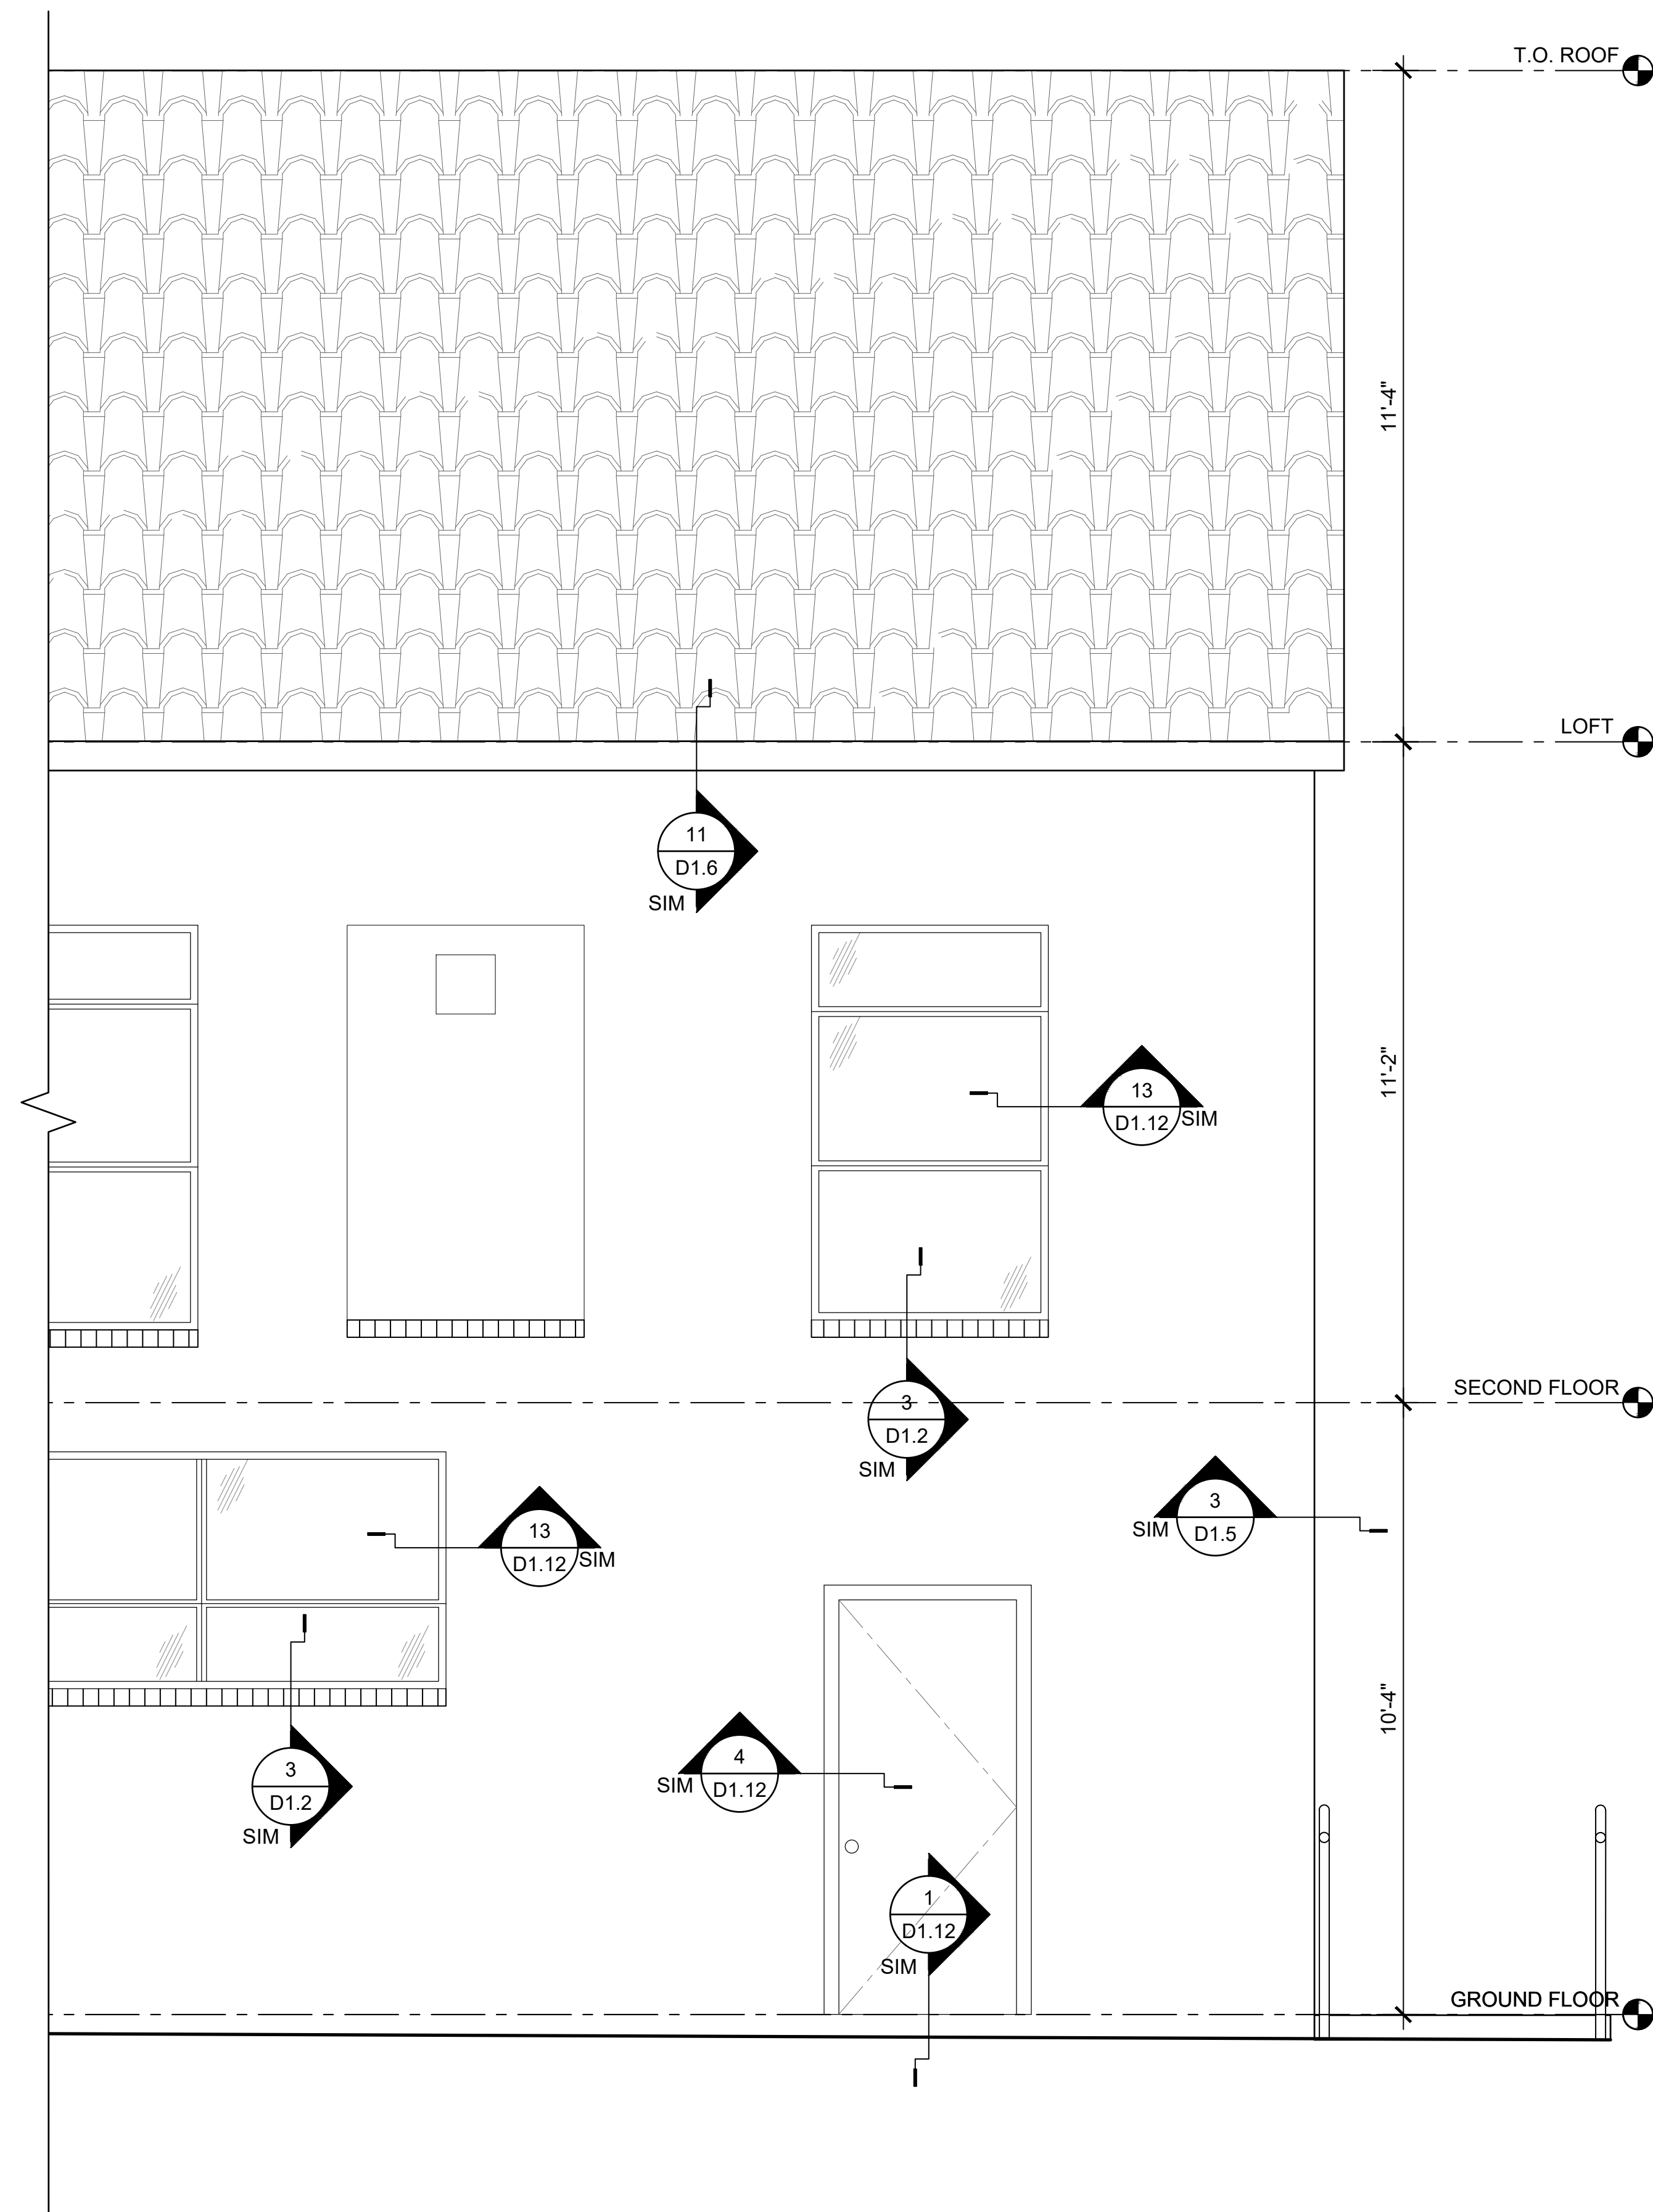

 2 BUILDING 5 ELEVATION - EAST
SCALE: 1/2"=1'-0"

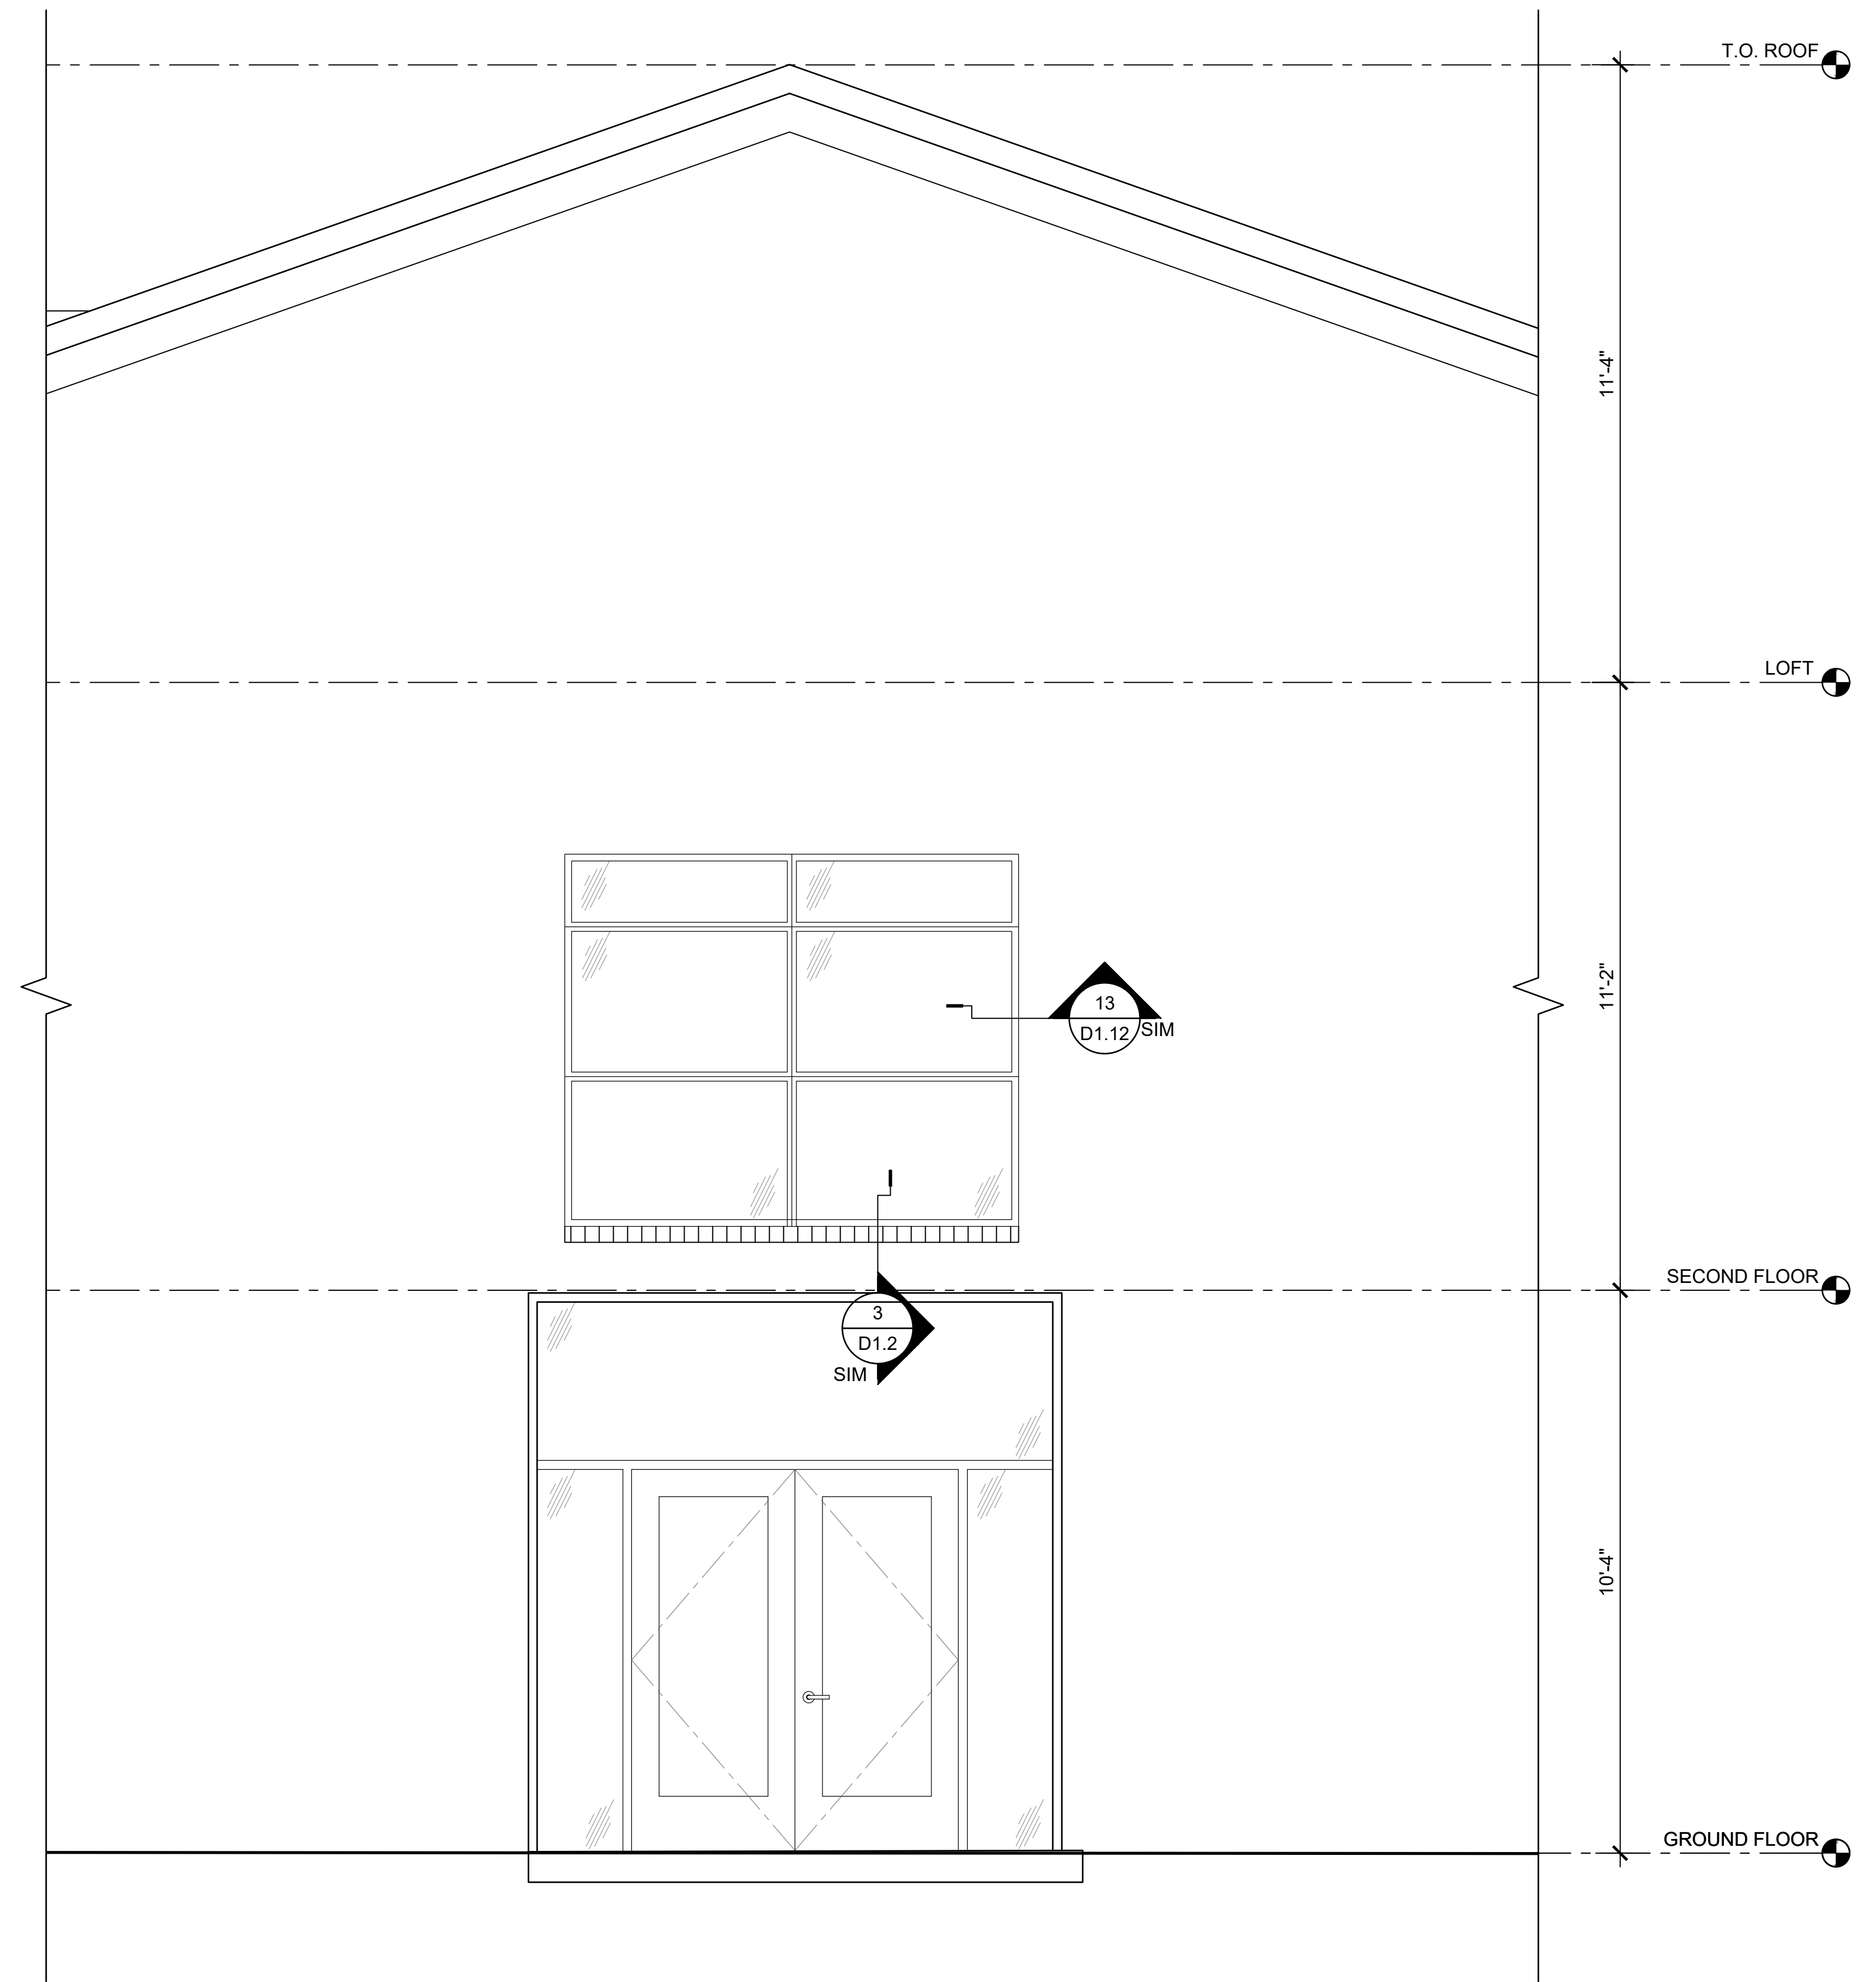

 1 BUILDING 5 ELEVATION - SOUTH
SCALE: 1/2"=1'-0"



PROJ. #	FILE #	23-42	23-42	Building 5 - Existing
DATE	9 APR 2025	REVISION		
DRAWN	AK	CHECKED	AK	


BUILDING 5
ELEVATIONS

ALL-SAINTS APARTMENTS
M.C. COMPANIES
ADDRESS
TUCSON, AZ


dean alan architects plc
150 THIRD AVENUE, SUITE 301
SEATTLE, WA 98101
TELEPHONE (206) 783-4086
www.deanalanarchitects.com

A5.24

_ OF _

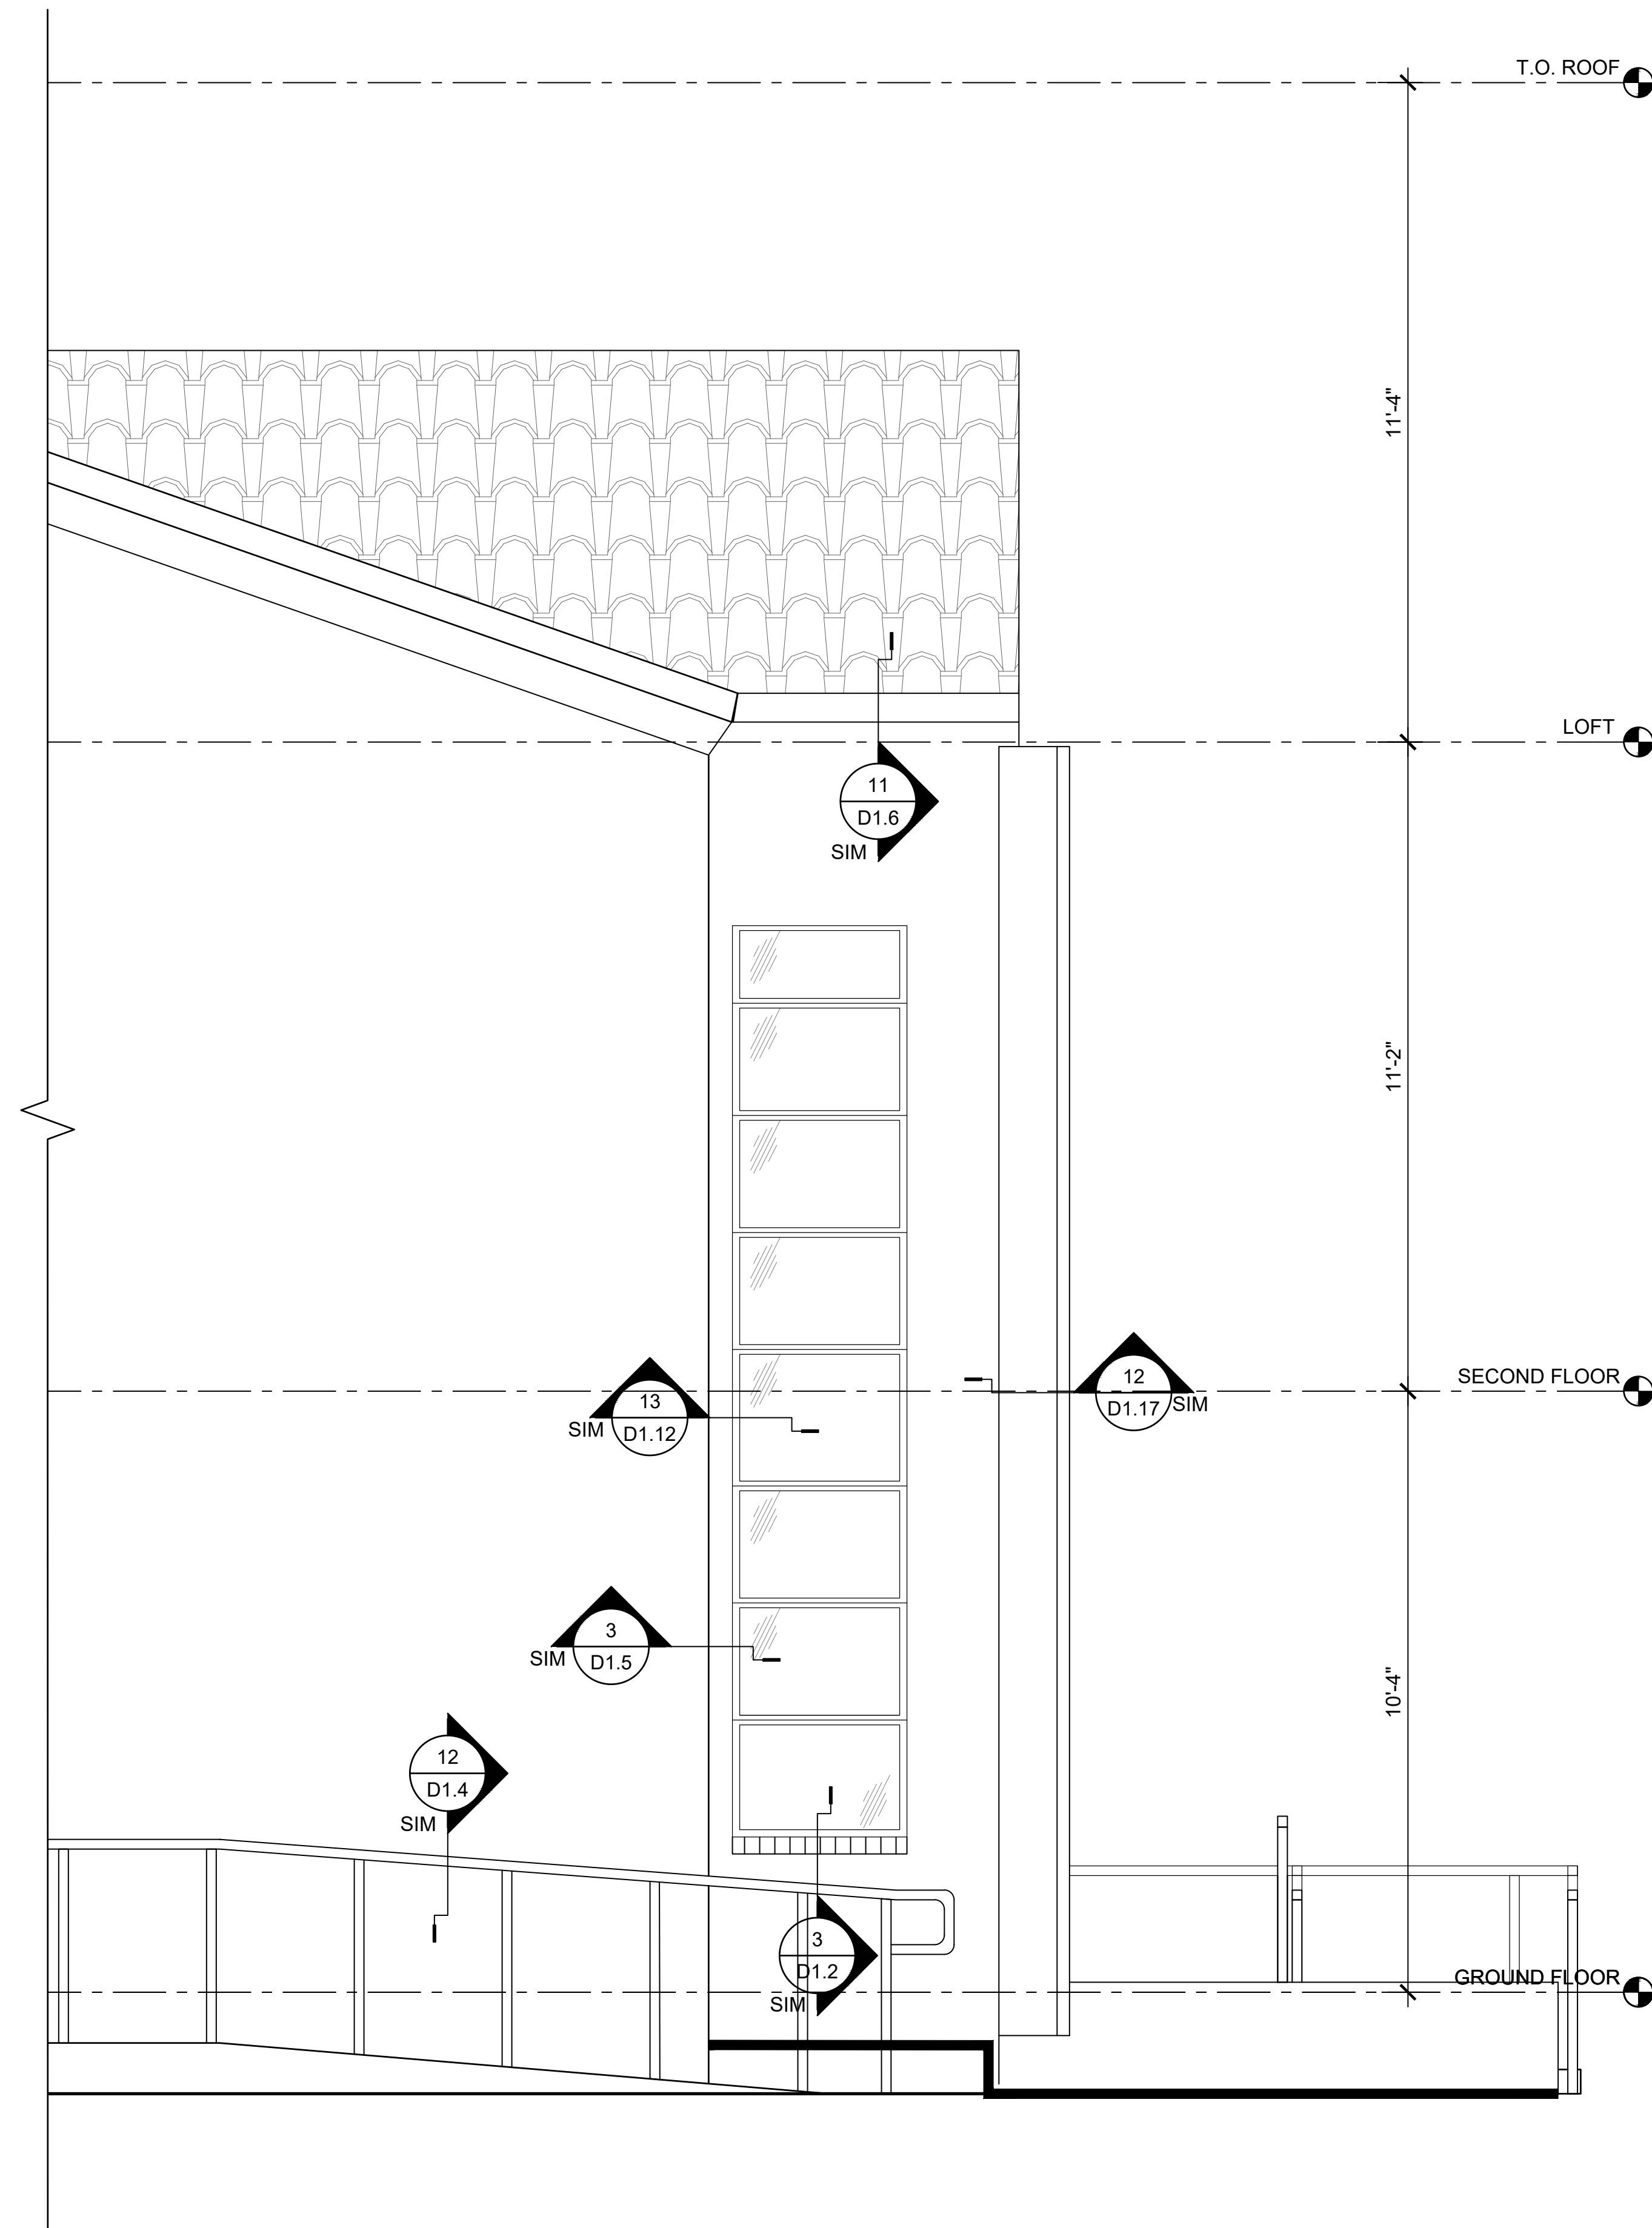

2 BUILDING 5 ELEVATION - NORTH
SCALE: 1/2"=1'-0"

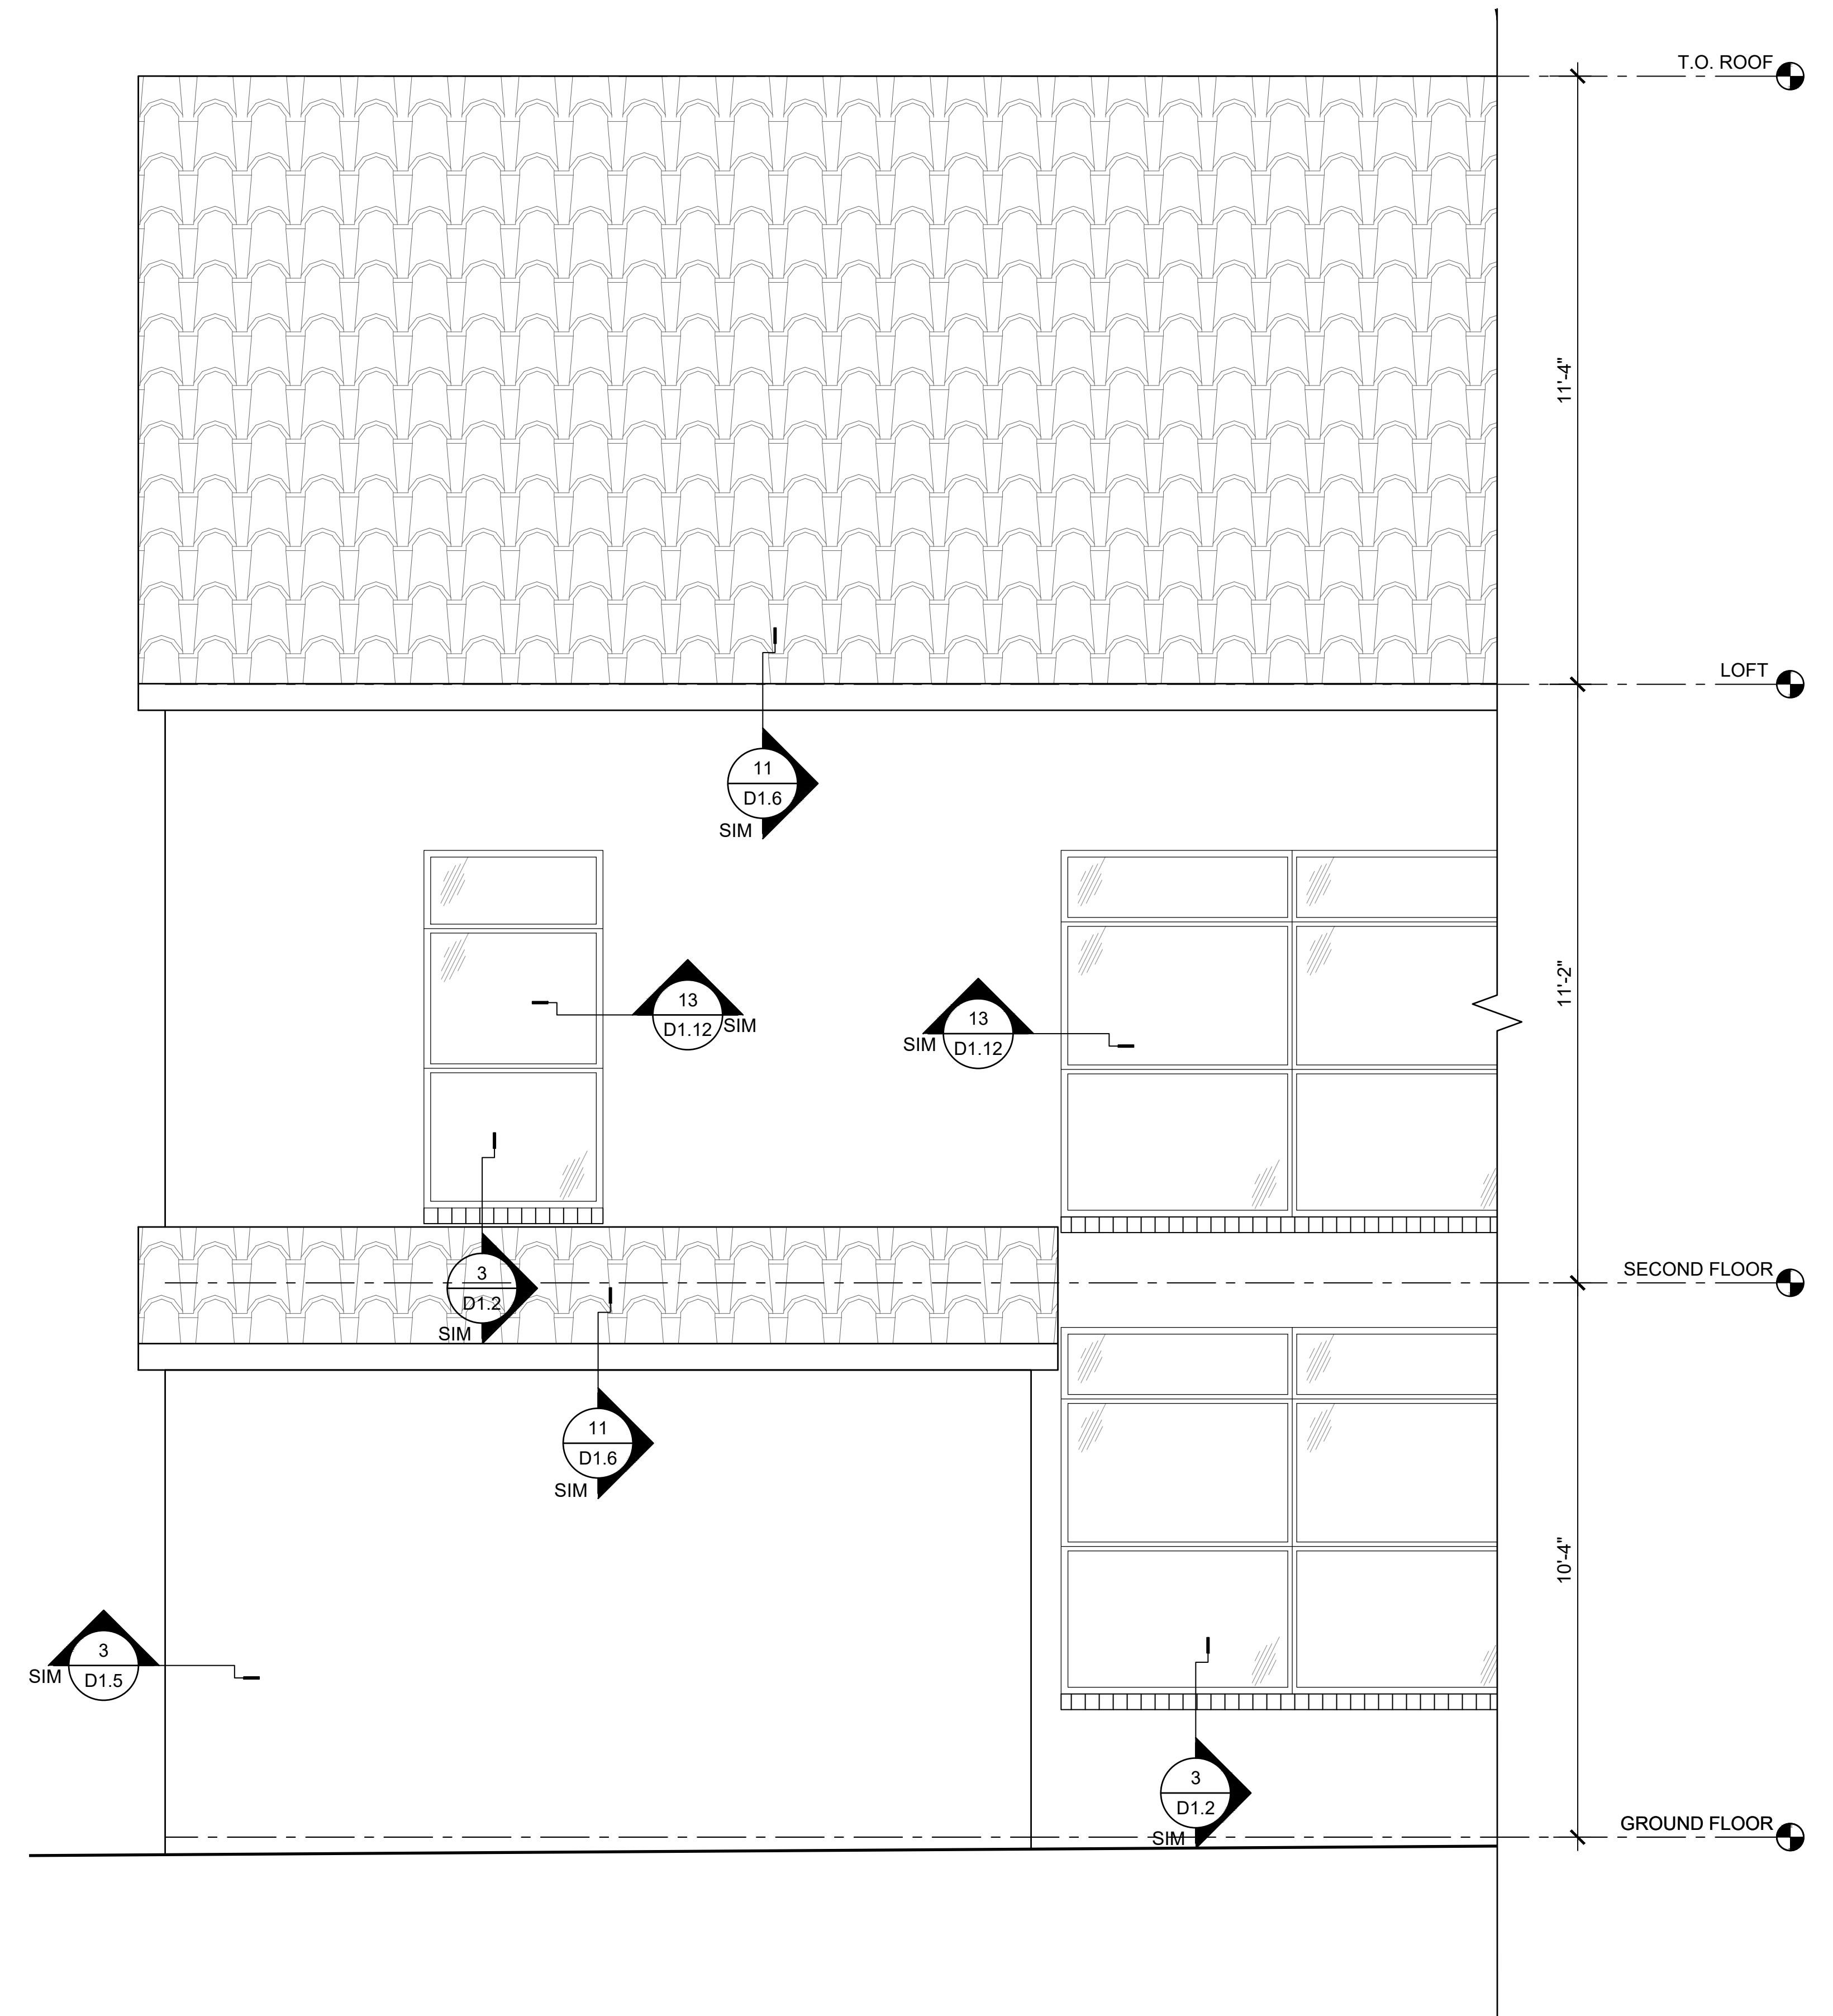

1 BUILDING 5 ELEVATION - EAST
SCALE: 1/2"=1'-0"

PROJ.#	FILE #	23-42	23-42	Building 5 - Existing
DATE	9 APR 2025	△	△	△
DRAWN	AK	△	△	△
CHECKED	AK	△	△	△



BUILDING 5
ELEVATIONS

ALL-SAINTS APARTMENTS
M.C. COMPANIES

clean alan architects plc
150 THIRD AVENUE, SUITE 301
SEATTLE, WA 98101
TELEPHONE (206) 783-4086
www.cleanalanarchitects.com

A5.25

_ OF _

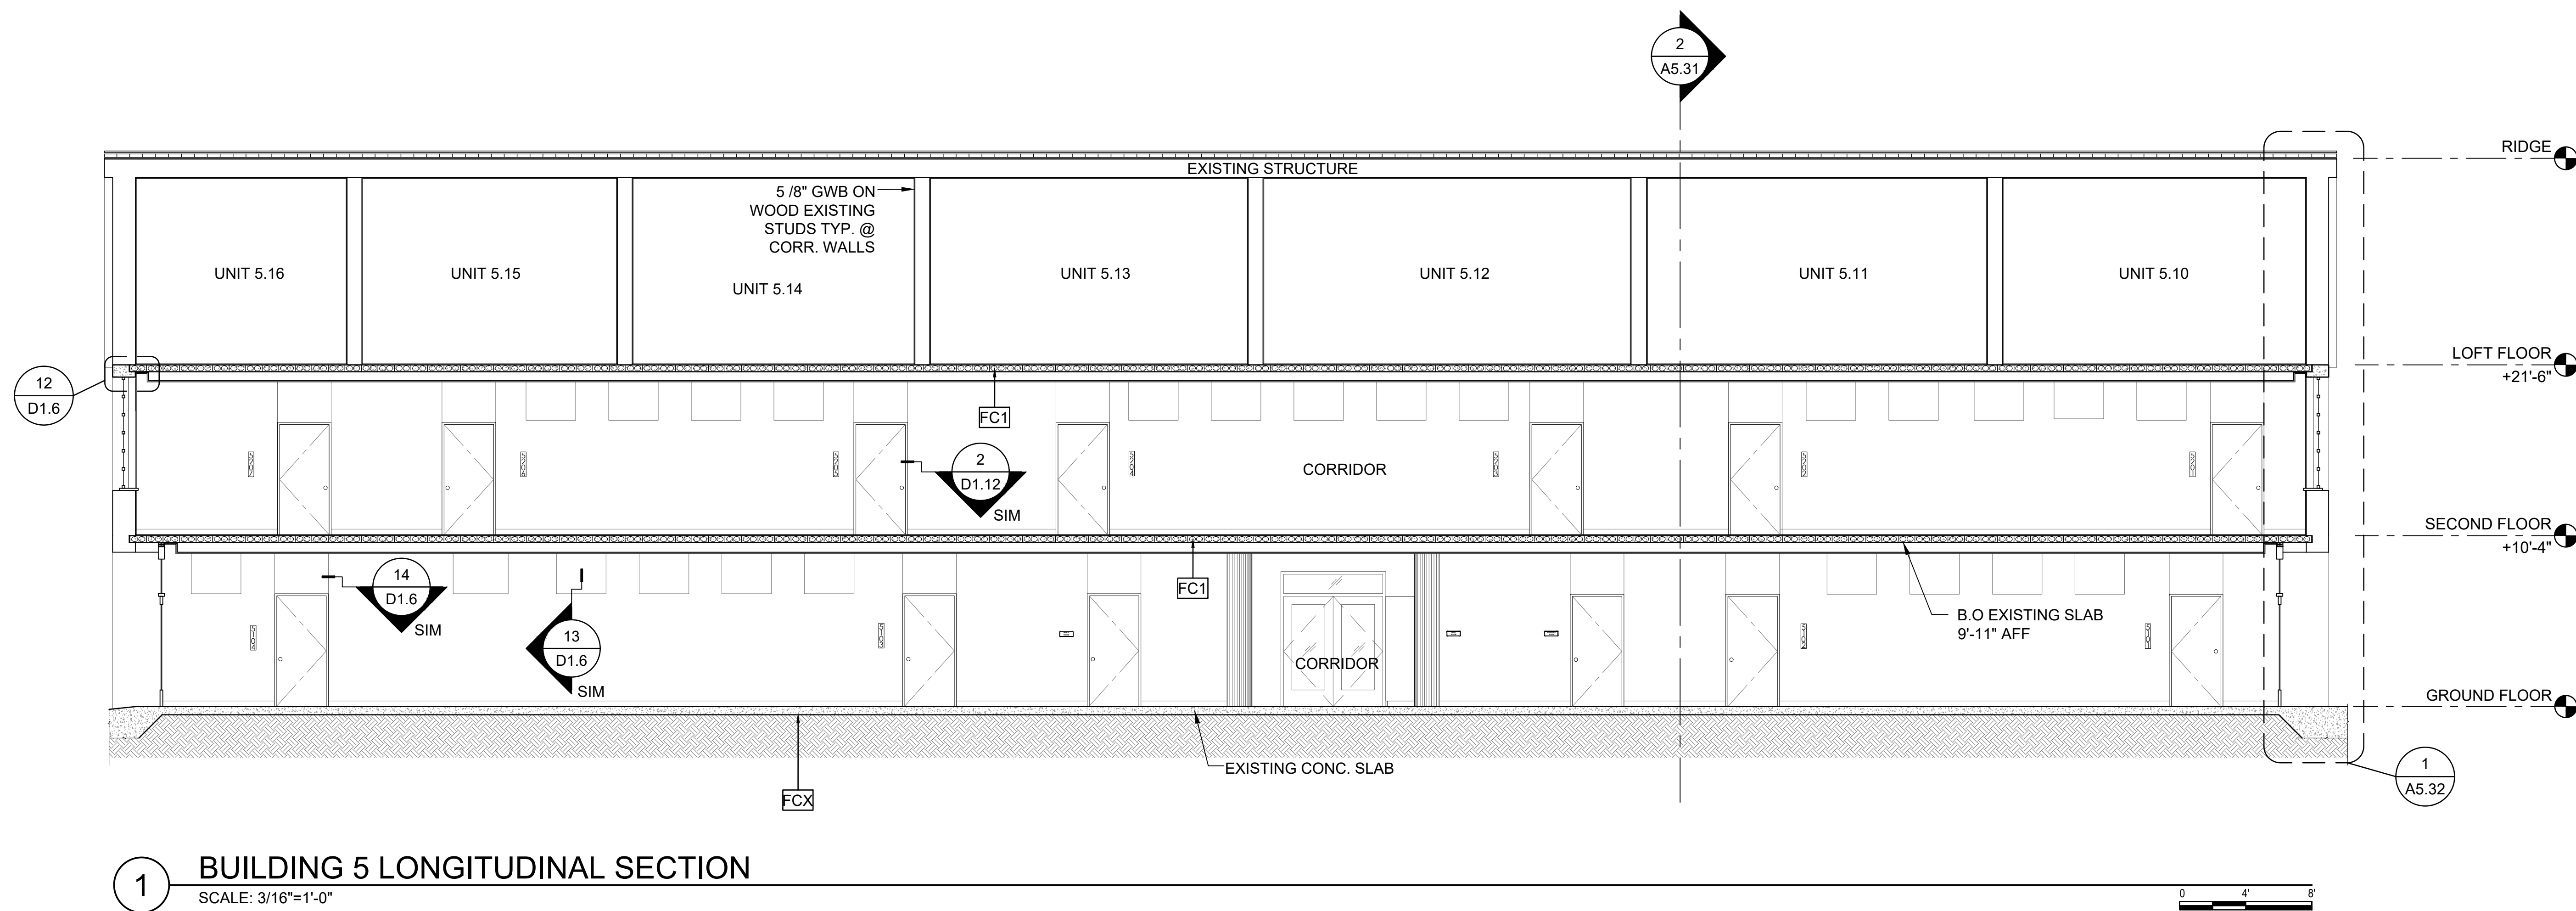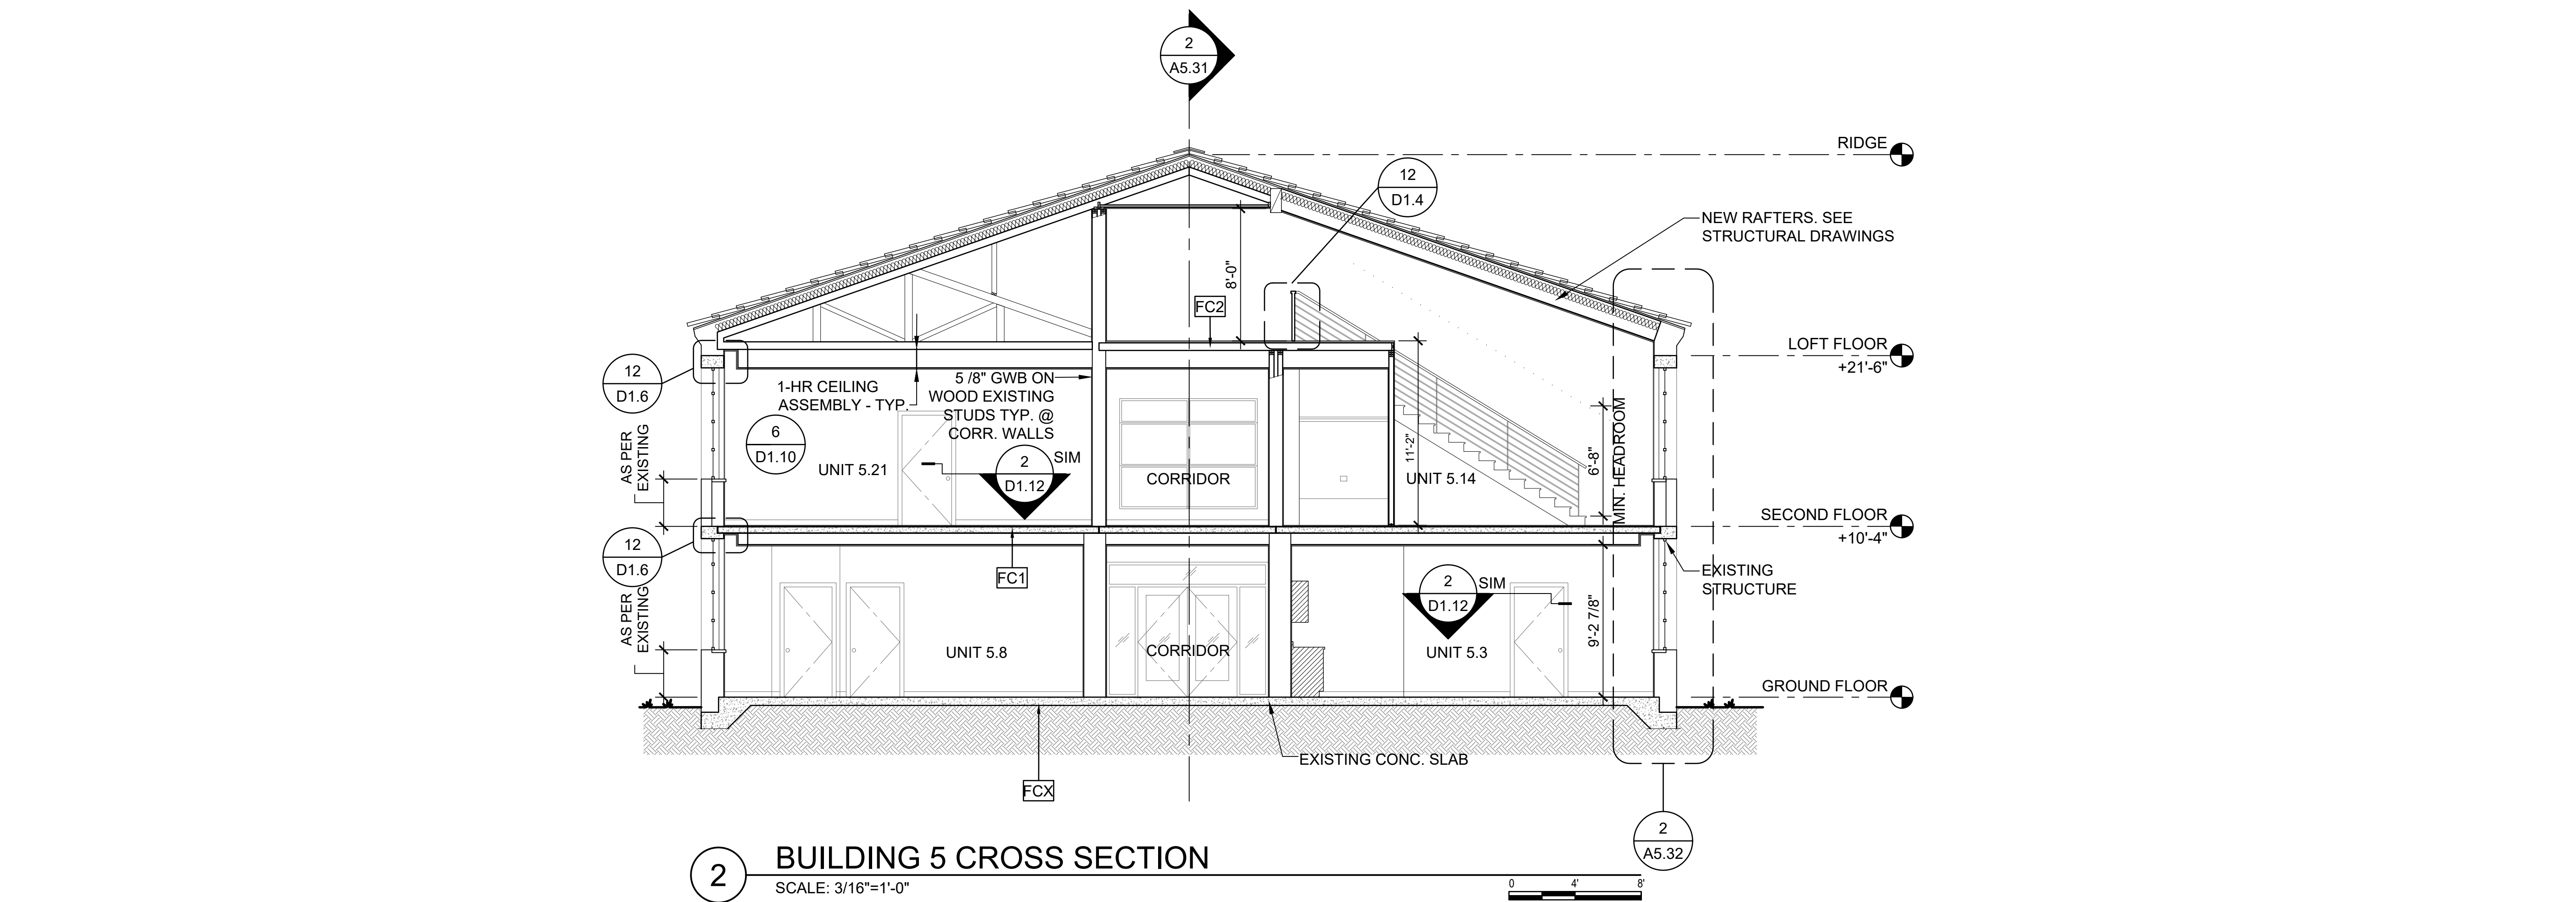

PROJ #	23-42	FILE #	23-42 - Building 5 - Existing
DATE	9 APR 2025	REVISION	
DRAWN	AK	CHECKED	AK

BUILDING 5
SECTIONS

ALL-SAINTS APARTMENTS
M.C. COMPANIES
ADDRESS
TUCSON, AZ

clean alan architects plc
150 THIRD AVENUE, SUITE 301
SEATTLE, WA 98101
TELEPHONE (206) 783-4086
www.cleanalanarchitects.com

A5.31

_ OF _